



ADDENDUM No. 1

Menominee County ISD, Central Elementary Fire Alarm UPEA Project No. M385-04227 (FA)

This **ADDENDUM NO. 1**, issued on November 25, 2025, is to clarify, modify and/or change the original plans and specifications issued by U.P. Engineers & Architects, Inc., and is hereby made a part of the bidding documents.

Bidders shall acknowledge receipt of this **ADDENDUM No. 1** on the appropriate place on the Bid Form.

Bidding and Contract Requirements:

1. Section 00 11 13: Advertisement for Bids. The bid due date is extended to Wednesday, December 3, 2025, 1:00 PM local time.

Specifications:

1. 28 31 11 – 5 Fire Detection and Alarm System. Section 2.1.F has been revised to allow additional vendor products for review other than Edwards.


F. Approved Products: All panels and peripheral devices shall be of the standard product of single manufacturer and shall display the manufacturer's name of each component. The catalog numbers specified under this section are those of Edwards (formerly EST), part of UTC Climate, Controls & Security and shall constitute the type, product quality, material and desired operating features. **ALTERNATE, OR EQUAL VENDOR EQUIPMENT MAY BE SUBMITTED TO THE ENGINEER FOR REVIEW.**

Drawings:

1. Pull Stations: E100, E101, E502 - Add pull station to exterior door of Boys D110 and Girls 111 and at bottom of stairs in Boiler Room D105. See attached revise plan.
2. Smoke Detectors: E100, E101, E103, and E502 – Additional smoke detectors added to rooms where deep structural members create overhead bays greater than 12" depth. See attached revised plan.

END OF ADDENDUM NO. 1

Prepared by:
U.P. Engineers & Architects, Inc.

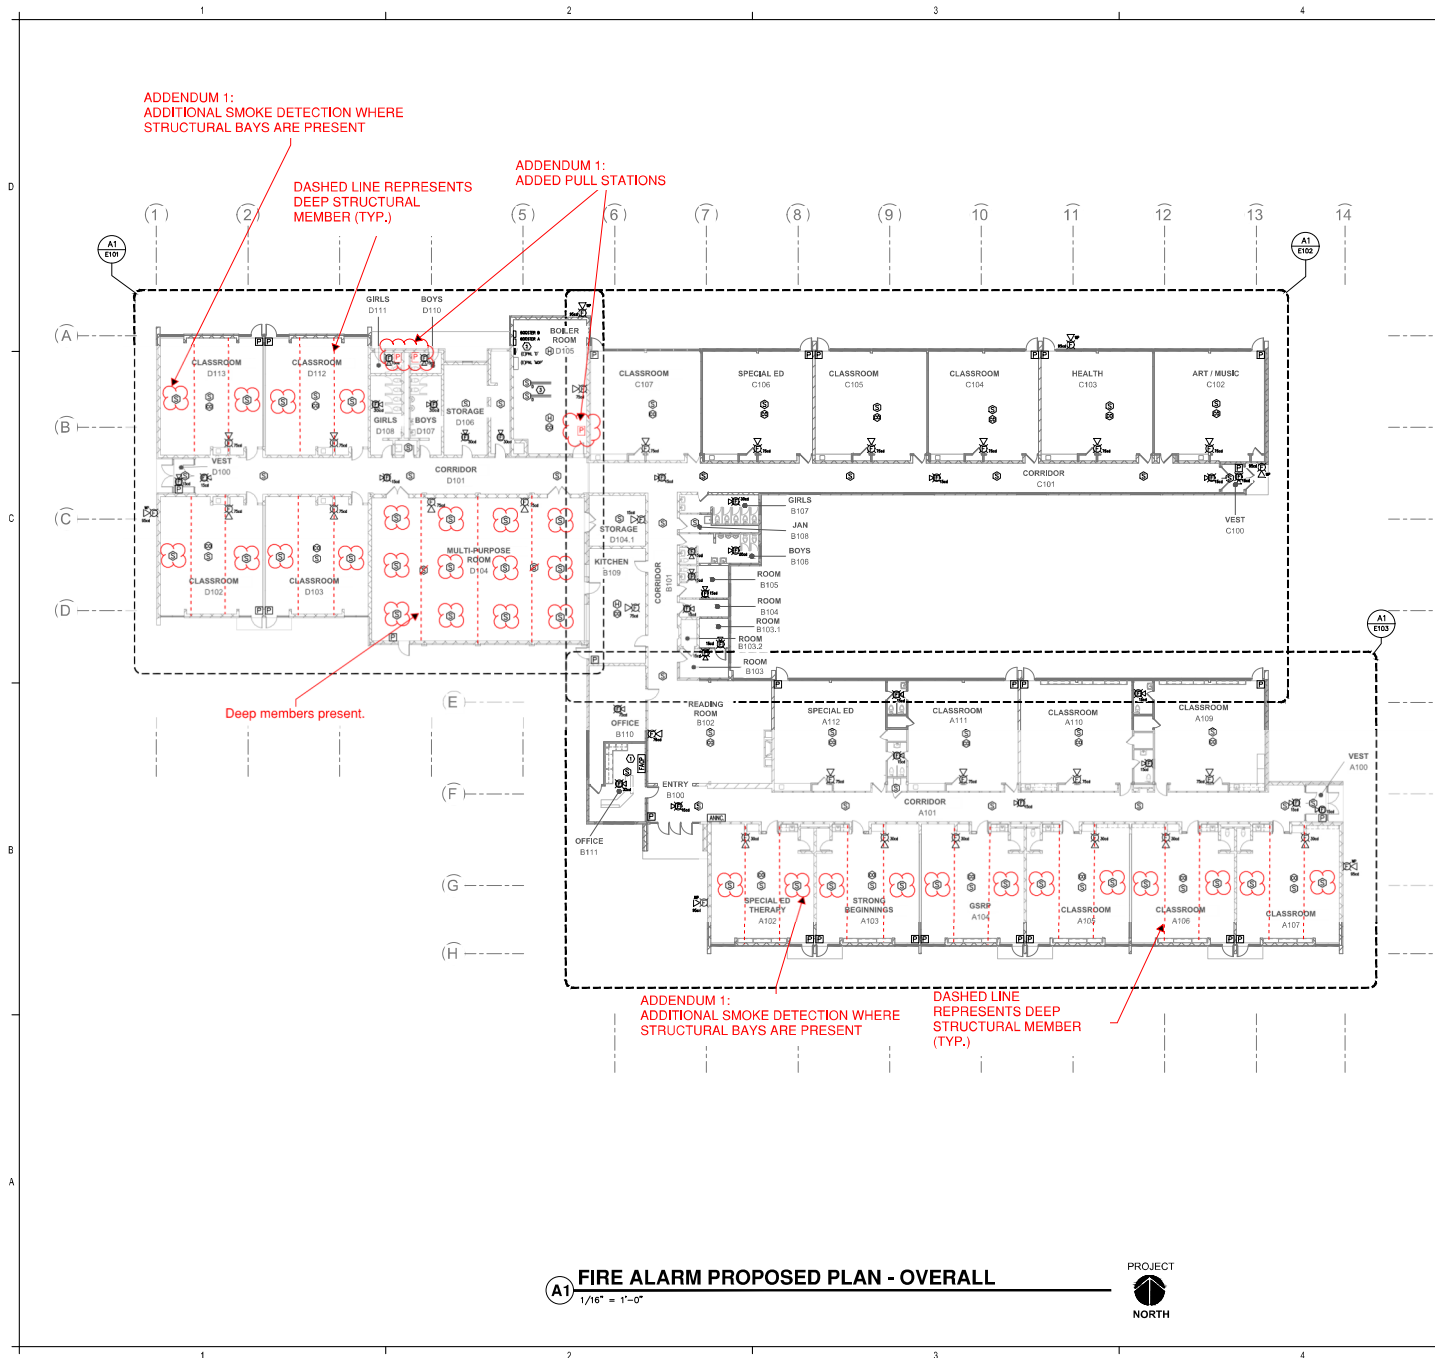

GENERAL NOTES

1. SHOP DRAWINGS FOR FIRE ALARM SYSTEM WILL BE SUBMITTED AS PART OF A DIFFERED SUBMITTAL BY SUCCESSFUL FIRE ALARM SYSTEM CONTRACTOR ONCE CONTRACT HAS BEEN AWARDED. PLANS ARE FOR BIDDING PURPOSES ONLY AT THIS TIME.
2. PROVIDE 50-1250 PROTECTIVE COVER ON ALL PULL STATIONS.
3. PROVIDE WIRE GUARD/CLEAR LEVEX COVER ON SMOKE DETECTOR AND SPEAKER/STROBE DEVICES IN MULTIPURPOSE ROOM.
4. FIRE ALARM SHALL BE IN COMPLIANCE WITH NFPA 72. INSTALLATION OF THE FIRE ALARM SYSTEM SHALL BE BY A FIRM CERTIFIED BY THE MICHIGAN DEPARTMENT OF CONSUMER INDUSTRIES SERVICES, OFFICE OF FIRE SAFETY. FIRE ALARM CONTRACTOR SHALL SUBMIT SHOP DRAWINGS AND ALL REQUIRED FORMS.

KEY NOTES

1. PROVIDE PHONE LINE AND DIALER OR CELLULAR DIALER AT MAIN FIRE ALARM CONTROL PANEL. PROVIDE OWNER WITH CONTRACT FOR FIRE ALARM SYSTEM MONITORING.
2. EXISTING SQUARE 'D' TYPE 60 LOAD CENTER PANEL 'D' TO REMAIN. PROVIDE (3) 20A/1P BRANCH CIRCUIT BREAKERS TO MATCH EXISTING IN PANEL TO FEED NEW FIRE ALARM CONTROL PANEL AND POWER BOOSTERS.
3. INSTALL DUCT MOUNTED SMOKE DETECTORS ON SUPPLY AND RETURN DUCTWORK OF EXISTING AHU SERVING MULTI-PURPOSE ROOM LOCATED IN BOILER ROOM. PROVIDE ALL NECESSARY DEVICES, WIRING, ETC. FOR EXISTING AHU TO SHUT DOWN UPON DETECTION OF SMOKE.

CENTRAL ELEMENTARY FIRE ALARM REPLACEMENT MENOMINEE COUNTY ISD MENOMINEE, MI 49858


DATE:	07-01-2023
REVIEW:	10-02-2023
ISSUED FOR:	FOR CONSTRUCTION
CENTRAL ELEMENTARY FIRE ALARM REPLACEMENT MENOMINEE COUNTY ISD	PROJECT NO: M385-0227
DESIGNED BY: AJM	DRAWN BY: KPS
CHECKED: PM	APPROVED: WKM

OVERALL PROPOSED PLAN

E100

A1 FIRE ALARM PROPOSED PLAN - OVERALL
1/16" = 1'-0"



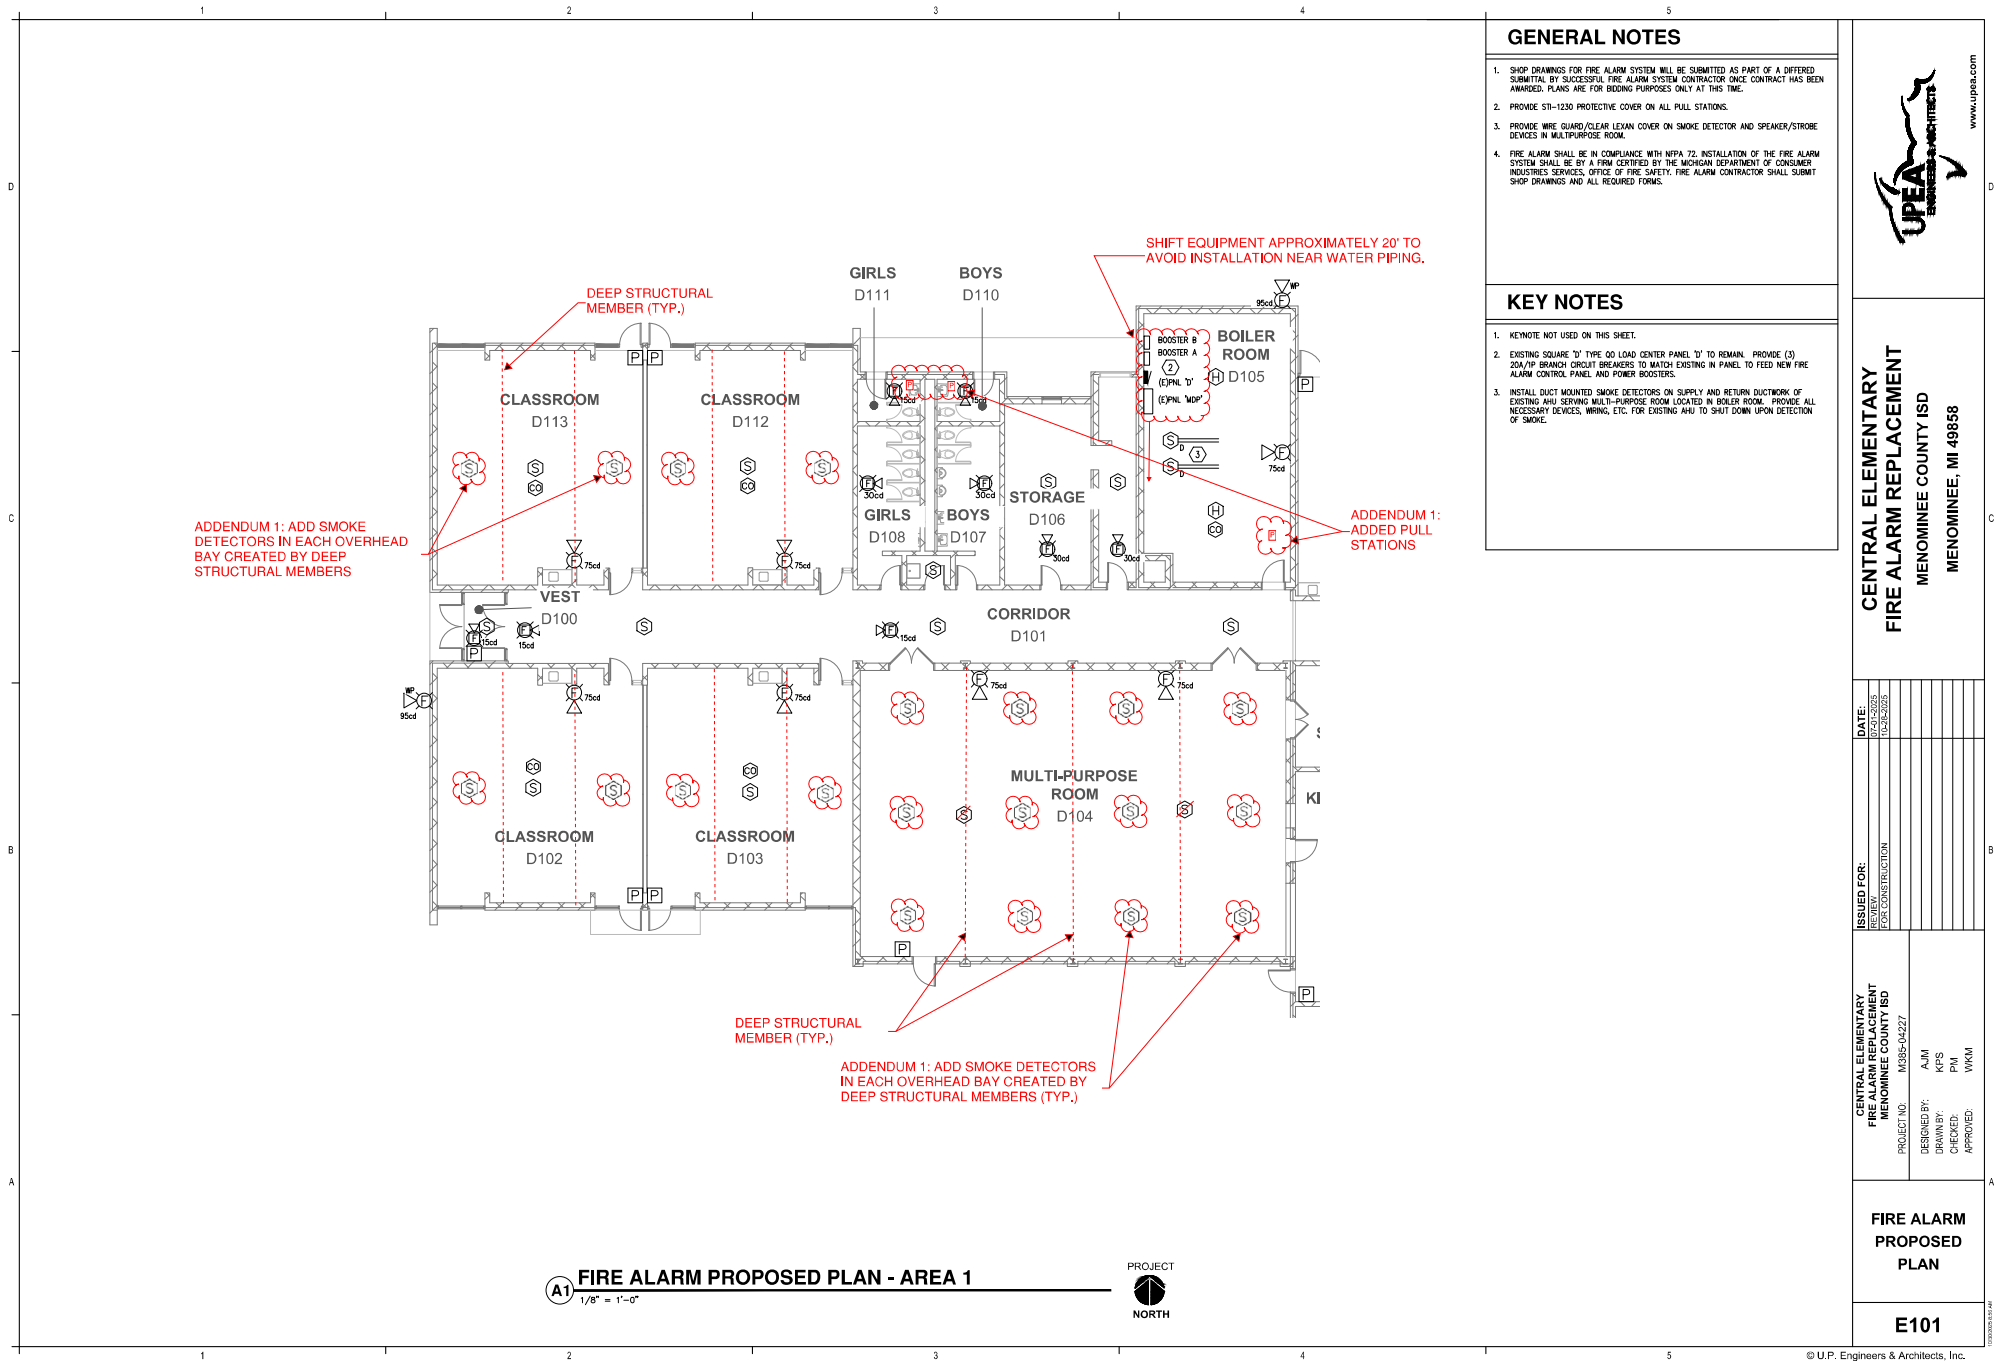


KEY NOTES

- 1. PROVIDE PHONE LINE AND DIALER OR CELLULAR DIALER AT MAIN FIRE ALARM CONTROL PANEL. PROVIDE OWNER WITH CONTRACT FOR FIRE ALARM SYSTEM MONITORING.

GENERAL NOTES

- 1. SHOP DRAWINGS FOR FIRE ALARM SYSTEM WILL BE SUBMITTED AS PART OF A DIFFERED SUBMITTAL BY SUCCESSFUL FIRE ALARM SYSTEM CONTRACTOR ONCE CONTRACT HAS BEEN AWARDED. PLANS ARE FOR RECORD PURPOSES ONLY AT THIS TIME.
- 2. PROVIDE 50-1230 PROTECTIVE COVER ON ALL PULL STATIONS.
- 3. PROVIDE WIRE GUARD/CLEAR LEAN COVER ON SMOKE DETECTOR AND SPEAKER/STROBE DEVICES IN MULTIPURPOSE ROOM.
- 4. FIRE ALARM SHALL BE IN COMPLIANCE WITH NFPA 72. INSTALLATION OF THE FIRE ALARM SYSTEM SHALL BE BY A FIRM CERTIFIED BY THE MICHIGAN DEPARTMENT OF CONSUMER INDUSTRIES SERVICES, OFFICE OF FIRE SAFETY. FIRE ALARM CONTRACTOR SHALL SUBMIT SHOP DRAWINGS AND ALL REQUIRED FORMS.

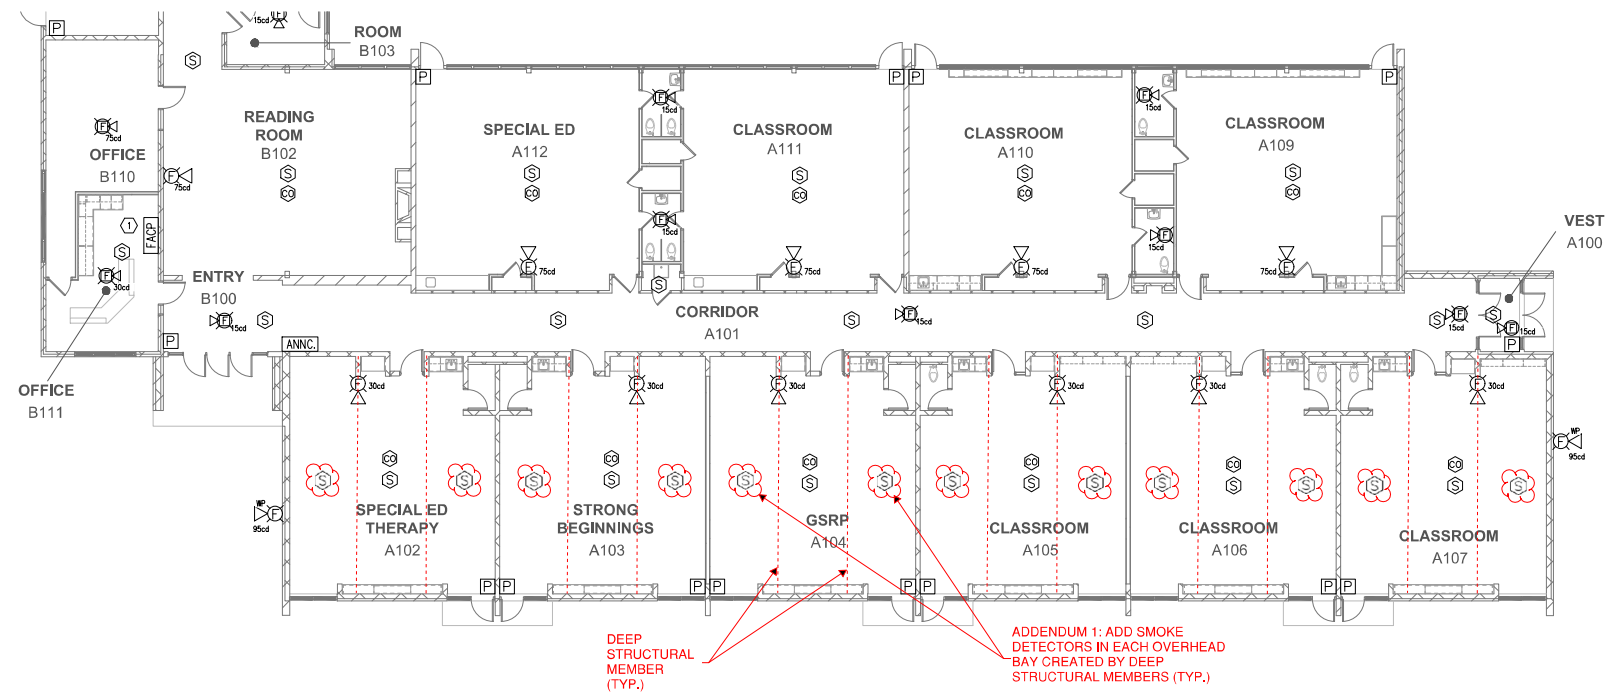

A1 FIRE ALARM PROPOSED PLAN - AREA 3
1/8" = 1'-0"



**CENTRAL ELEMENTARY
FIRE ALARM REPLACEMENT
MENOMINEE COUNTY ISD
MENOMINEE, MI 49858**

DATE:	07-01-2023
ISSUED FOR:	REVIEW FOR CONSTRUCTION
CENTRAL ELEMENTARY FIRE ALARM REPLACEMENT MENOMINEE COUNTY ISD	PROJECT NO: M385-0227
DESIGNED BY: AJM	DRAWN BY: KPS
CHECKED: PM	APPROVED: WKM

**FIRE ALARM
PROPOSED
PLAN**

E103



