

CENTRAL ELEMENTARY INTERIOR RENOVATION - PHASE 1

MENOMINEE COUNTY ISD
MENOMINEE, MI 49858

U.P. ENGINEERS & ARCHITECTS, INC.

100 PORTAGE STREET
HOUGHTON, MI 49931
P (906) 482-4810
F (906) 482-9799

424 S. PINE ST.
ISHPEMING, MI 49849
P (906) 485-1011
F (906) 485-1013

1701 DUNLAP AVE., SUITE B
MARINETTE, WI 54143
P (715) 732-4188
F (715) 732-4189

707 ASHMUN STREET
SAULT STE. MARIE, MI 49783
P (906) 635-0511
F (906) 635-0612

2906 N. STEPHENSON AVE, SUITE 2
IRON MOUNTAIN, MI 49801
P (906) 779-0937
F (906) 779-0947



www.upea.com

SHEET INDEX

NUMBER	SHEET NAME
G001	COVER
AD101	ARCHITECTURAL DEMOLITION - 1ST FLOOR PLAN
A101	ARCHITECTURAL PLANS - 1ST FLOOR - OVERALL
A201	EXTERIOR ELEVATIONS
A401	ARCHITECTURAL PLANS - 1ST FLOOR - ENLARGED
A402	ARCHITECTURAL PLANS - 1ST FLOOR - ENLARGED
A403	INTERIOR ELEVATIONS
A404	INTERIOR ELEVATIONS
A601	ARCHITECTURAL SCHEDULES AND TYPES - ROOM
A602	ARCHITECTURAL SCHEDULES AND TYPES - DOOR

CODE INFORMATION

PROJECT NAME: MENOMINEE COUNTY INTERMEDIATE SCHOOL DISTRICT, MENOMINEE, MICHIGAN

AUTHORITY HAVING JURISDICTION (AHJ): STATE OF MICHIGAN BUREAU OF CONSTRUCTION CODES AND BUREAU OF FIRE SERVICES

GOVERNING CODE:

- 2021 MICHIGAN BUILDING CODE (2021 IBC AMENDED)
- 2021 MICHIGAN REHABILITATION CODE FOR EXISTING BUILDINGS (2021 IEBC AMENDED)
- 2021 MICHIGAN PLUMBING CODE (2021 IPC AMENDED)
- 2012 NFPA LIFE SAFETY CODE PLUS MICHIGAN AMMENDMENTS

CONTRACTOR SHALL COMPLY WITH ALL APPLICABLE SECTIONS OF THE GOVERNING CODES AND ALL APPLICABLE REFERENCES TO OTHER CODES AND STANDARDS. THE MORE RESTRICTIVE PROVISION SHALL GOVERN WHERE APPLICABLE CODE REQUIREMENTS DIFFER.

THIS IS NOT A COMPLETE OR COMPREHENSIVE LIST OF ALL CODE REQUIREMENTS FOR THE SCOPE OF WORK. THE FOLLOWING IS ONLY A SUMMARY OF SELECT CODE SECTIONS CONSIDERED RELEVANT TO GUIDE THE DESIGN OF THE PROJECT.

CHAPTER	REFERENCE	APPLICATION / REQUIREMENT	SUPPORT / NOTES / CALCULATIONS
IEBC Chapter 5 Classification of Work	Alteration - Level 1 Section 503	Chapter 7 shall apply.	One-for-one replacement of casework and plumbing fixtures. Alterations do not exceed 50% of building area.
IEBC Chapter 7 Alterations - Level 1	Fire Protection Section 703	Renovation shall maintain the current level of fire protection provided.	
	Means of Egress Section 704	Renovation shall maintain the current level of protection provided for the means of egress.	
	Accessibility Section 705	Renovation shall maintain current level of accessibility.	



Know what's below.
Call before you dig.

CENTRAL ELEMENTARY INTERIOR RENOVATION - PHASE 1

MENOMINEE COUNTY ISD
MENOMINEE, MI 49858


ISSUED FOR:	DATE:
OWNER REVIEW	02-20-2025
OWNER REVIEW	04-04-2025
PLAN REVIEW	04-11-2025
BIDDING	04-25-2025

CENTRAL ELEMENTARY INTERIOR
RENOVATION - PHASE 1
MENOMINEE COUNTY ISD
PROJECT NO: M385-04227

DESIGNED BY: JHR
DRAWN BY: JHR
CHECKED: WKM
APPROVED: WKM

COVER

G001

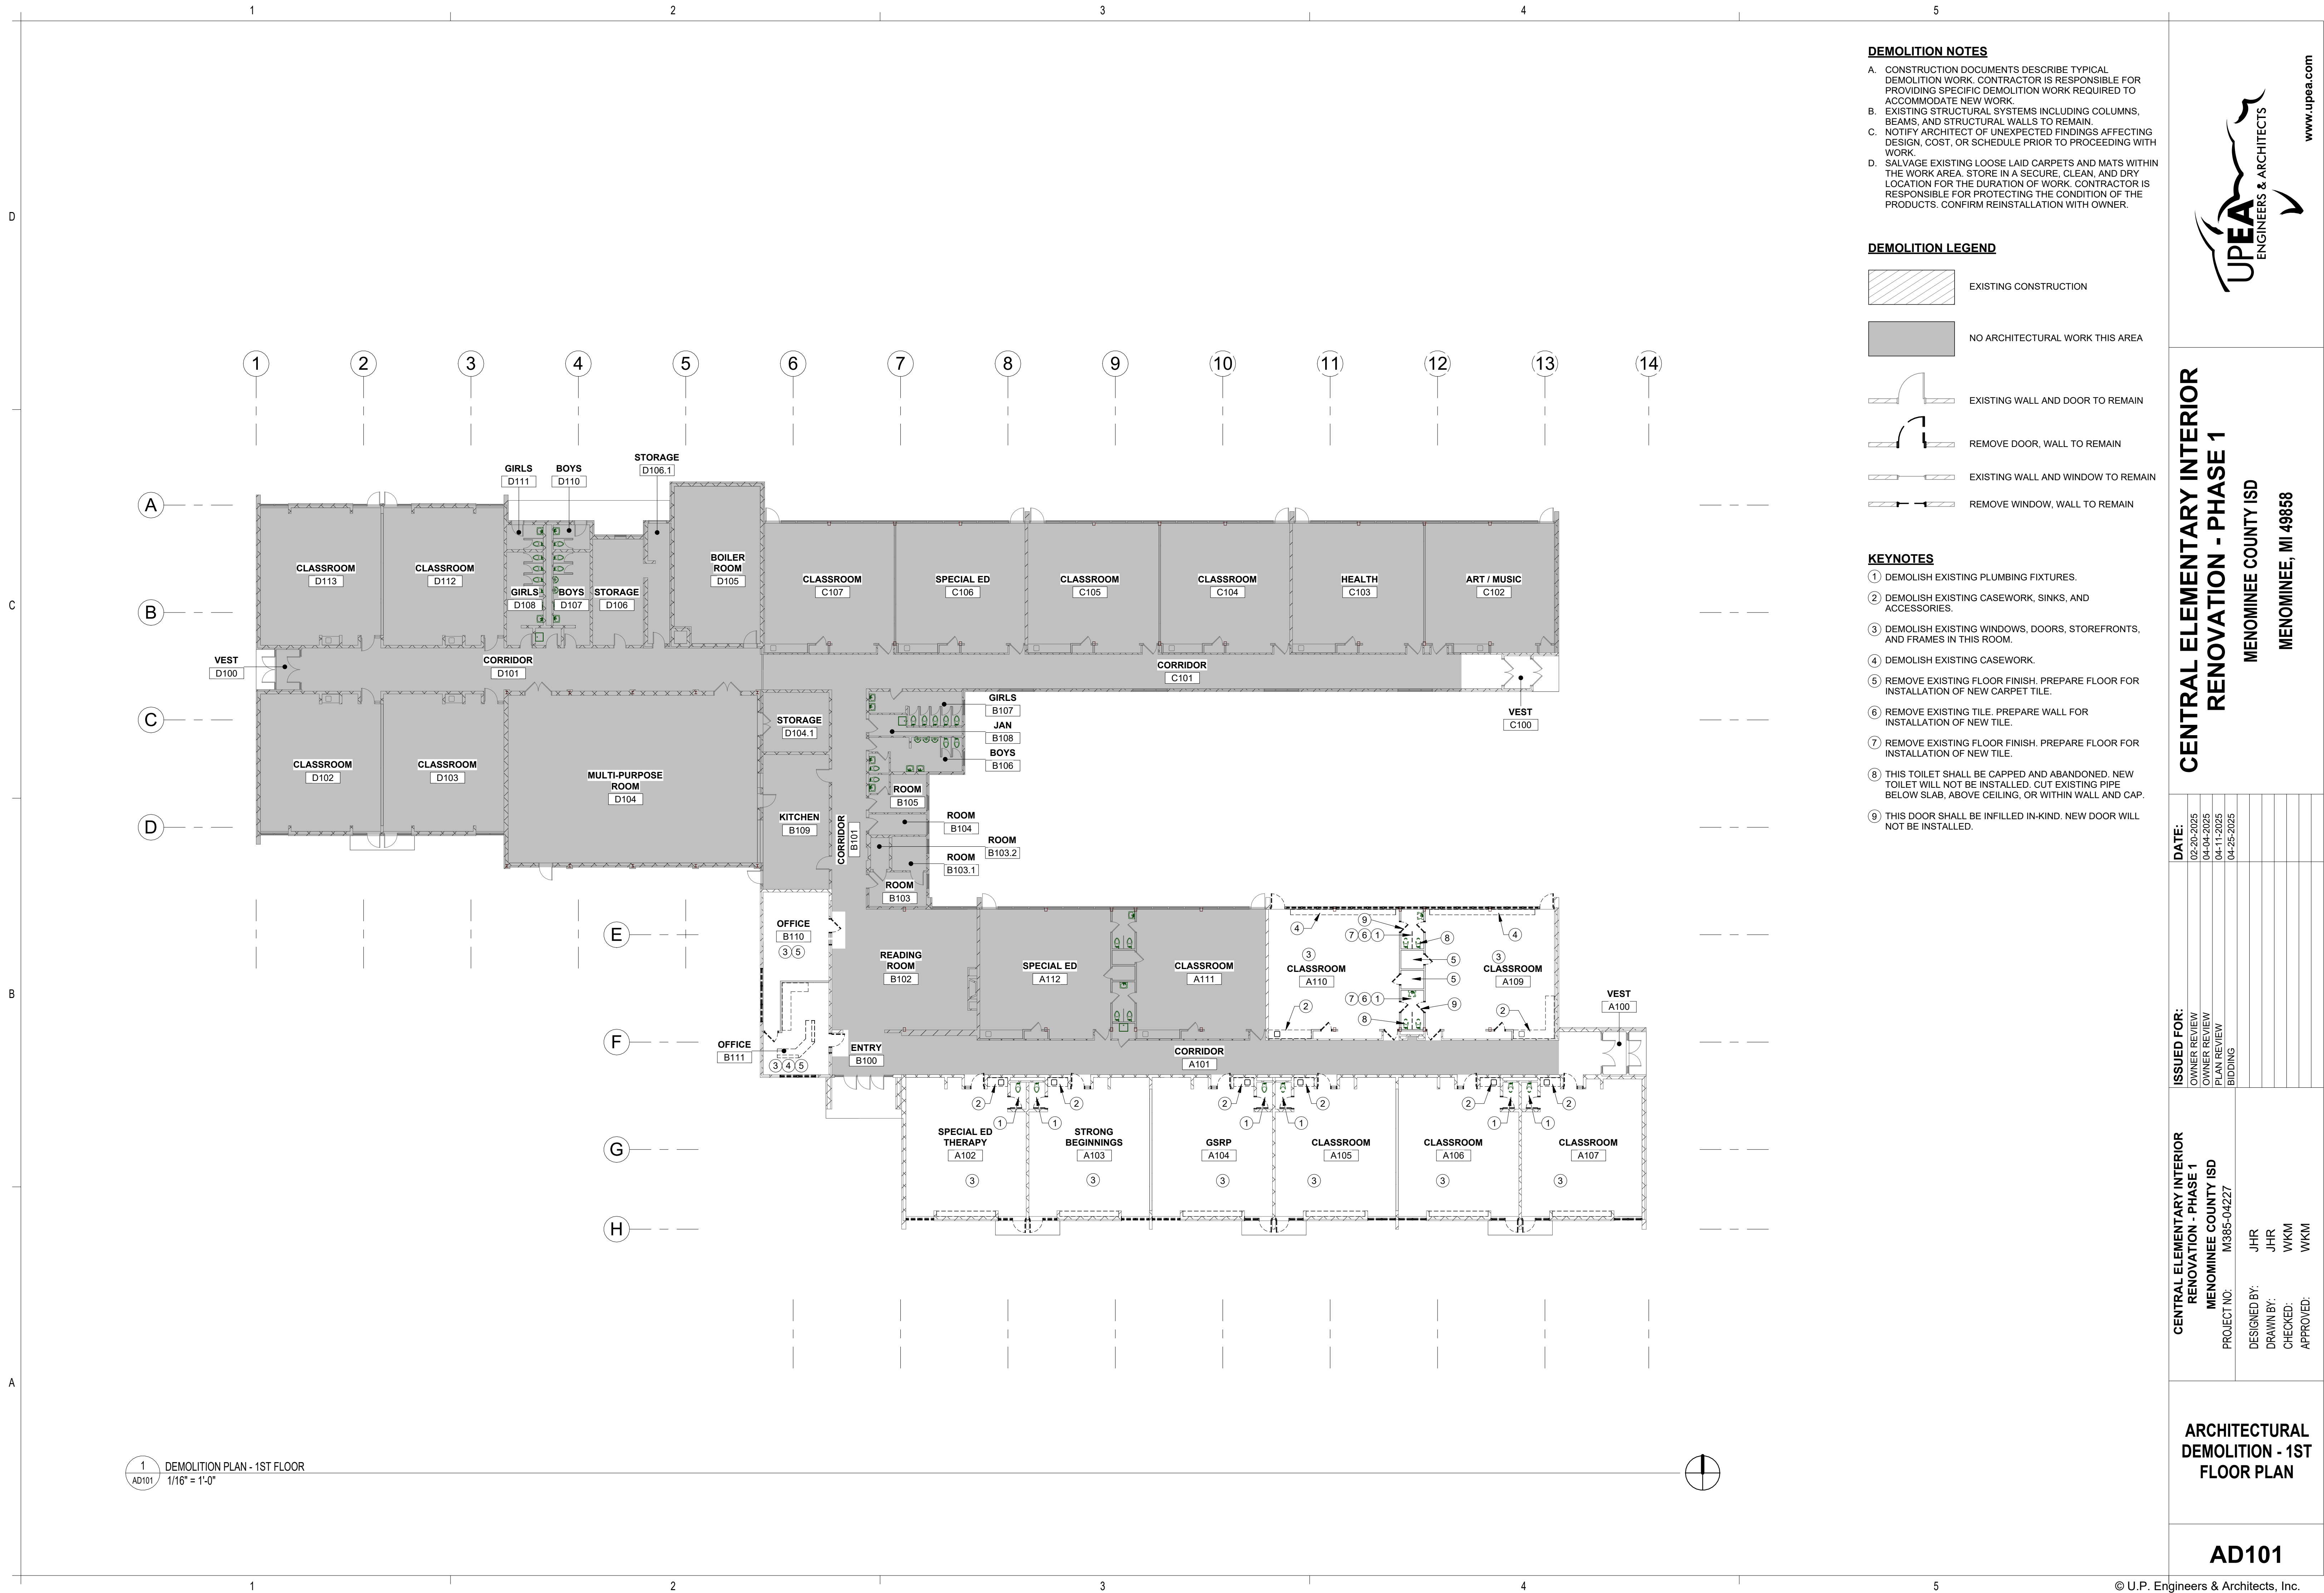

www.upea.com

CENTRAL ELEMENTARY INTERIOR RENOVATION - PHASE 1

MENOMINEE COUNTY ISD
MENOMINEE, MI 49858


ISSUED FOR:	DATE:
OWNER REVIEW	02-20-2025
OWNER REVIEW	04-04-2025
PLAN REVIEW	04-11-2025
BIDDING	04-25-2025

CENTRAL ELEMENTARY INTERIOR RENOVATION - PHASE 1
MENOMINEE COUNTY ISD
PROJECT NO: M385-04227

DESIGNED BY: JHR
DRAWN BY: JHR
CHECKED: WKM
APPROVED: WKM

ARCHITECTURAL DEMOLITION - 1ST FLOOR PLAN

AD101

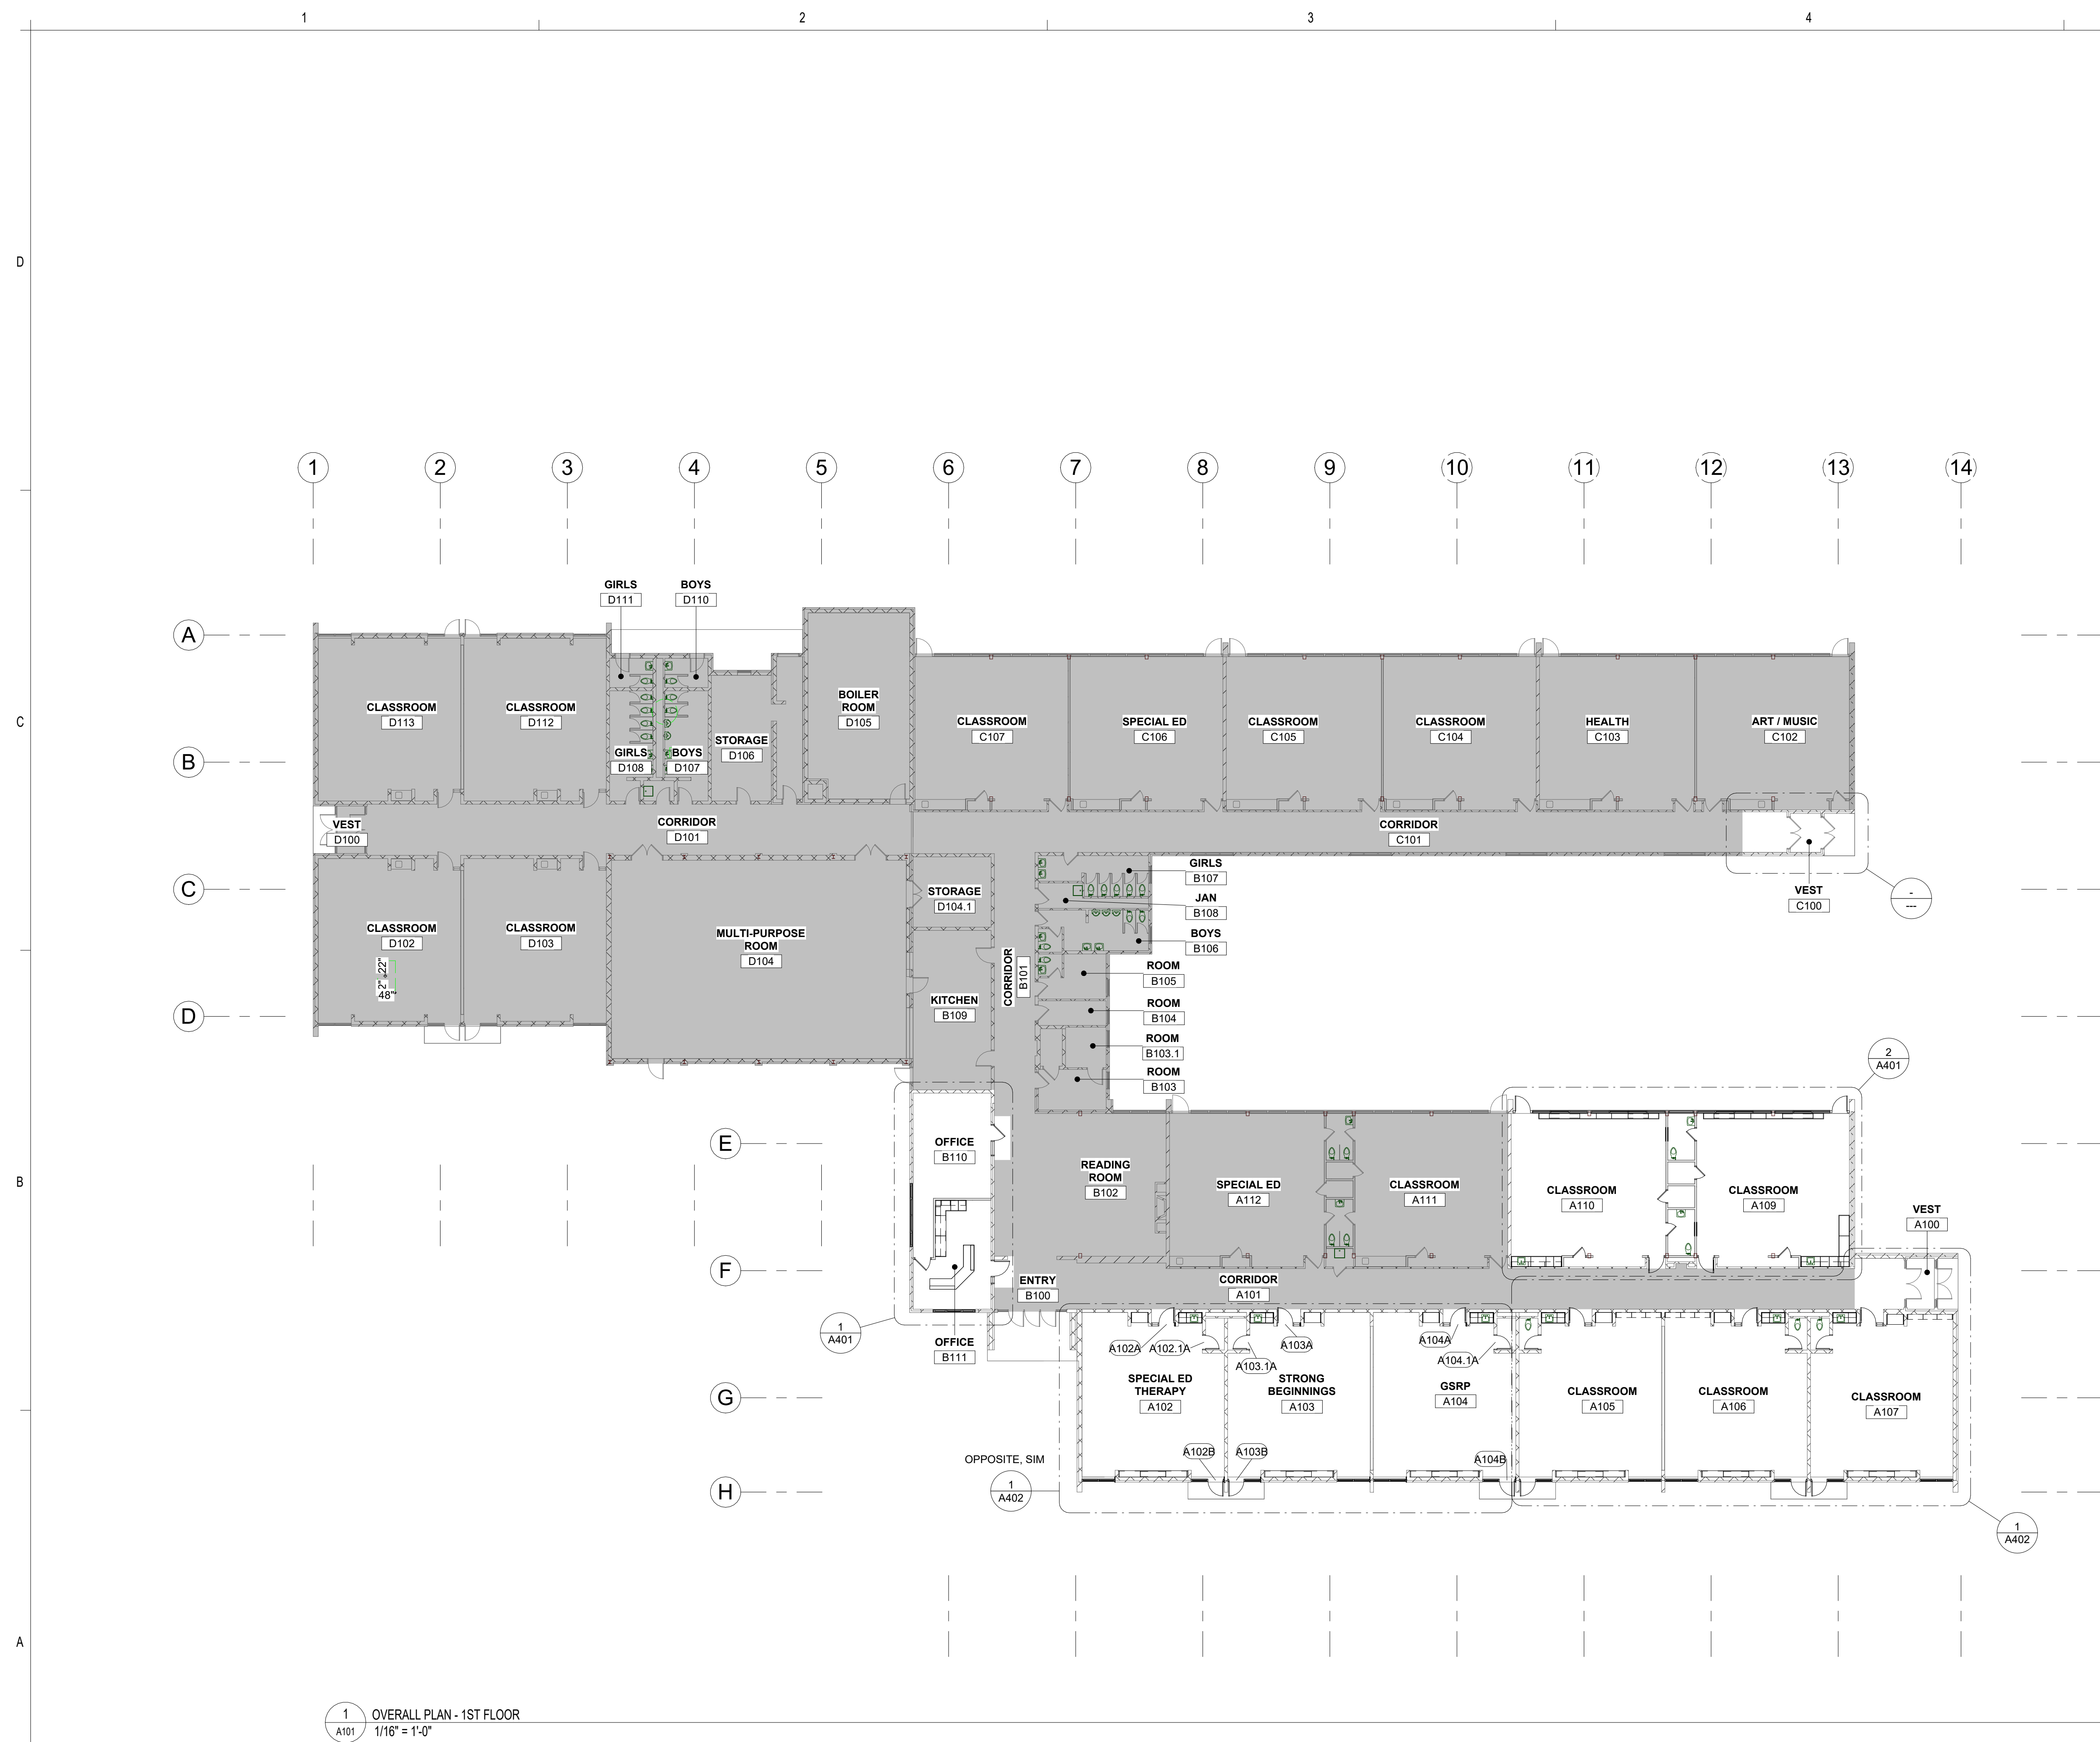

**CENTRAL ELEMENTARY INTERIOR
RENOVATION - PHASE 1**

MENOMINEE COUNTY ISD




MENOMINEE, MI 49858

MENOMINEE COUNTY ISD
MENOMINEE, MI 49858

CENTRAL ELEMENTARY INTERIOR RENOVATION - PHASE 1		ISSUED FOR:	DATE:
MENOMINEE COUNTY ISD	PROJECT NO:	M385-04227	
	DESIGNED BY:	JHR	
	DRAWN BY:	JHR	
	CHECKED:	WKMM	
	APPROVED:	WKMM	
		OWNER REVIEW	02-20-2025
		OWNER REVIEW	04-04-2025
		PLAN REVIEW	04-11-2025
		BIDDING	04-25-2025

**ARCHITECTURAL
PLANS - 1ST FLOOR
- OVERALL**

   A101



CENTRAL ELEMENTARY INTERIOR RENOVATION - PHASE 1

MENOMINEE COUNTY ISD
MENOMINEE, MI 49858

[illegible]

**CENTRAL ELEMENTARY INTERIOR
RENOVATION - PHASE 1
MENOMINEE COUNTY ISD**

PROJECT NO: M385-04227

DESIGNED BY: JHR
DRAWN BY: JHR
CHECKED: WKM
APPROVED: WKM

EXTERIOR ELEVATIONS

A201



- ① PROVIDE NEW JUVENILE TOILET. BASIS OF DESIGN: KOHLER JUVENILE ULTRA K-9609-0. CONTRACTOR SHALL VERIFY ROUGH-IN SIZE PRIOR TO PROCUREMENT.
- ② PROVIDE NEW URINAL SCREEN. BASIS OF DESIGN: ASI ACCURATE PARTITIONS. HDPE, WALL MOUNTED.
- ③ PROVIDE NEW WALL MOUNTED JUVENILE LAVATORY. BASIS OF DESIGN: KOHLER GREENWICH K-2030-0. WITH FAUCET: BASIS OF DESIGN: KOHLER HINT K-97093-4-CP.
- ④ PROVIDE NEW UNDERMOUNT STAINLESS STEEL SINK. BASIS OF DESIGN: KOHLER STRIVE K-33153-NA. WITH FAUCET: BASIS OF DESIGN: KOHLER RIVAL K-30470-CP.



CENTRAL ELEMENTARY INTERIOR RENOVATION - PHASE 1

MENOMINEE COUNTY ISD
MENOMINEE, MI 49858





	ISSUED FOR:	DATE:
	OWNER REVIEW	02-20-2025
	OWNER REVIEW	04-04-2025
	PLAN REVIEW	04-11-2025
	BIDDING	04-25-2025

DESIGNED BY:	JHR
DRAWN BY:	JHR
CHECKED:	WKM
APPROVED:	WKM

**ARCHITECTURAL
PLANS - 1ST FLOOR
- ENLARGED**

    A401





**CENTRAL ELEMENTARY INTERIOR
RENOVATION - PHASE 1**

MENOMINEE COUNTY ISD

MENOMINEE, MI 49858

[illegible]

**CENTRAL ELEMENTARY INTERIOR
RENOVATION - PHASE 1
MENOMINEE COUNTY ISD
PROJECT NO: M385-04227**

INTERIOR ELEVATIONS


A403




www.upea.com

4/22/2025 10:33:20 AM A P:\W385-04227 MCISD-Central Elementary Renovation for ISD\Drawings\W385-04227_ARCH_R24_Phase1_Interior_new.vt


© U.P. Engineers & Architects, Inc.

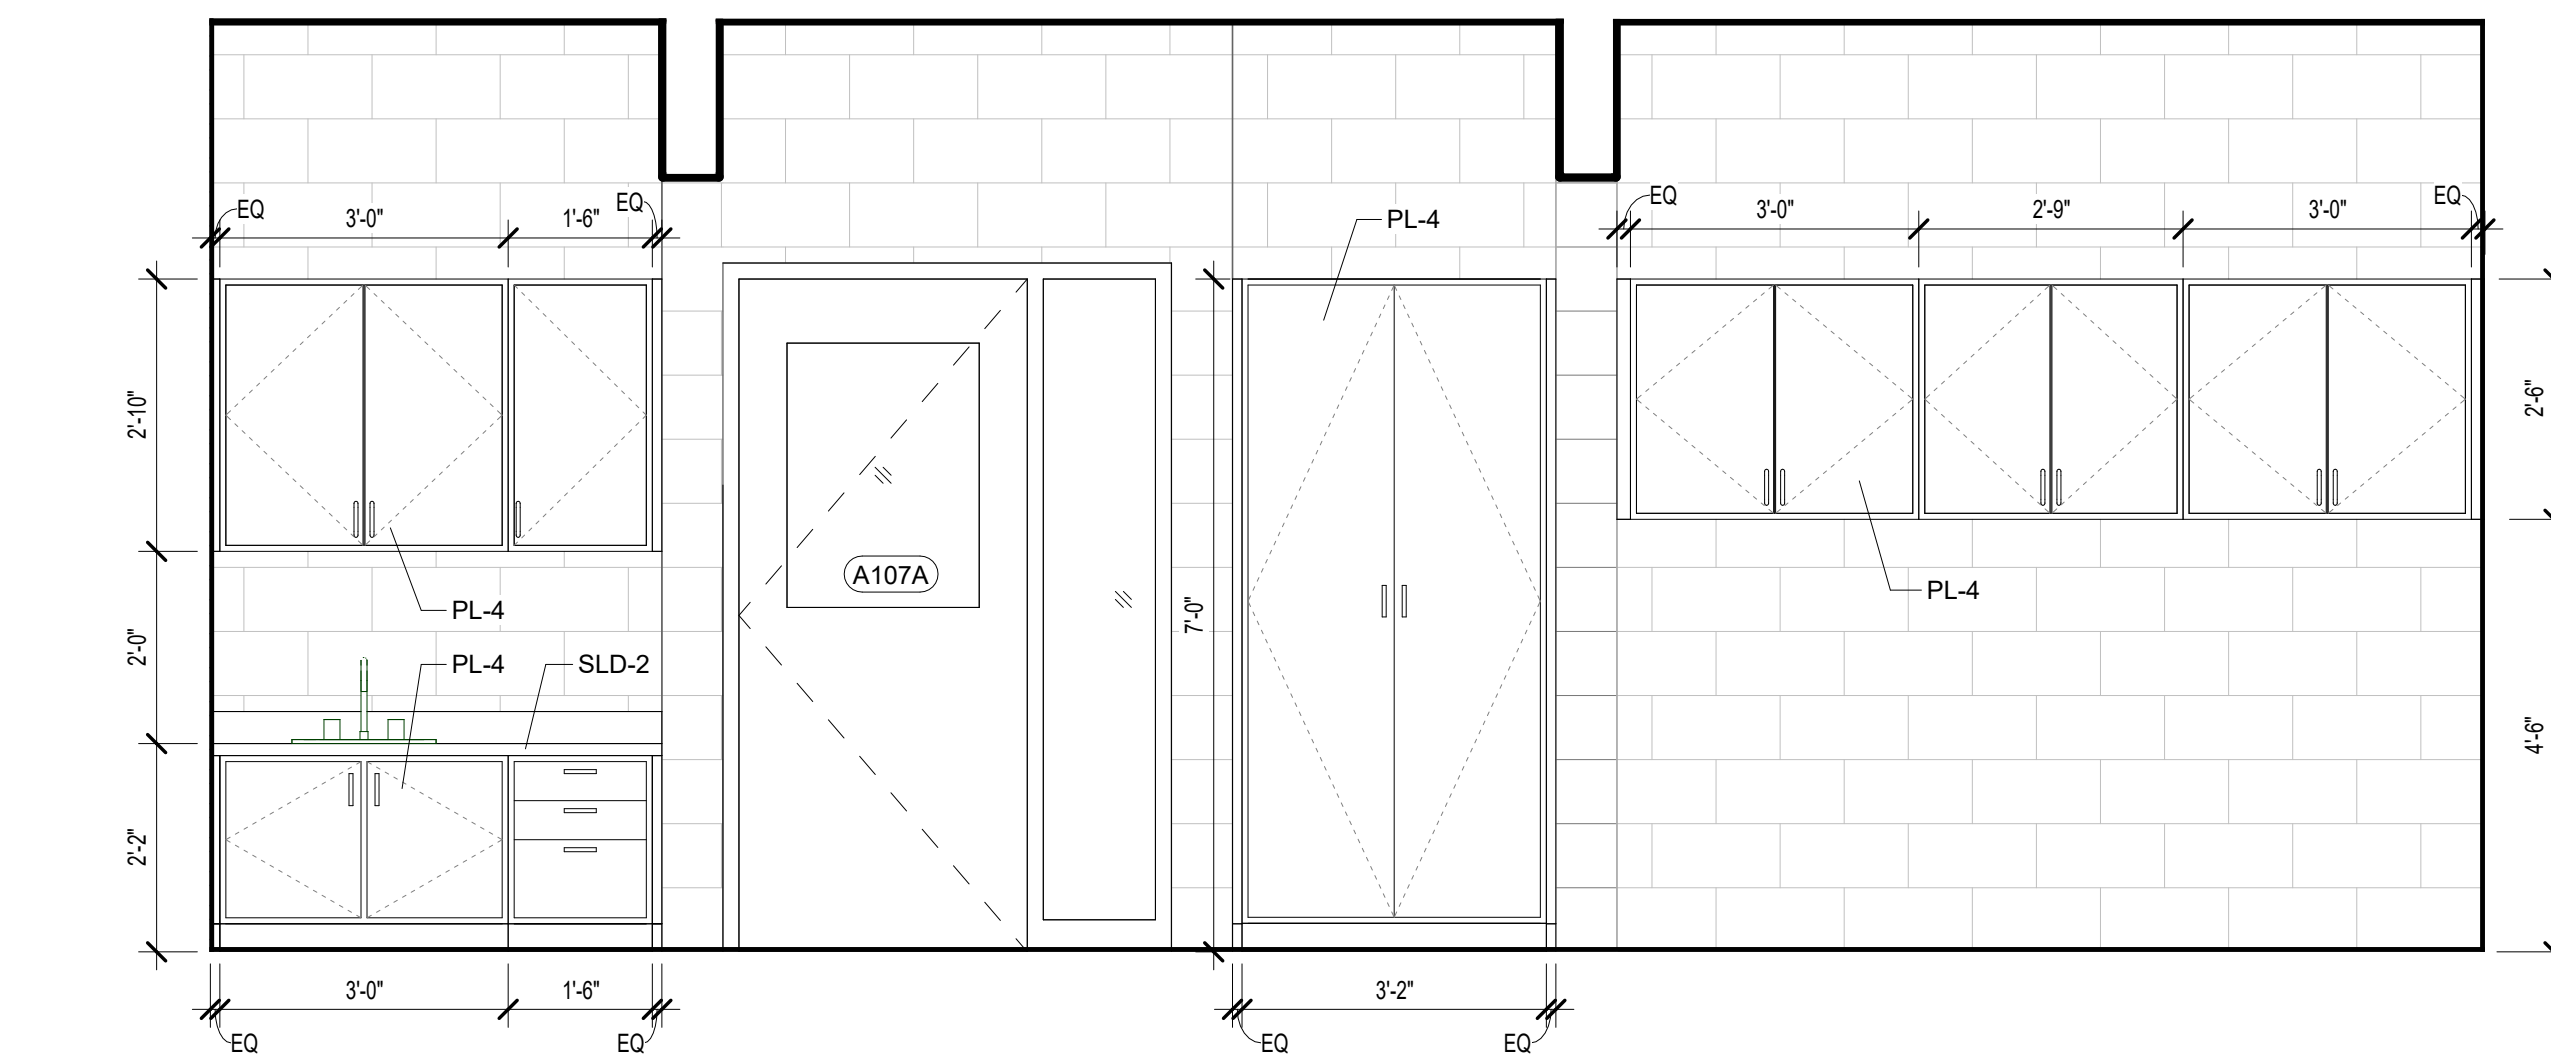


1 INTERIOR ELEVATION - CASEWORK - CLASSROOMS A102 & A107 - NORTH
A404 1/2" = 1'-0"

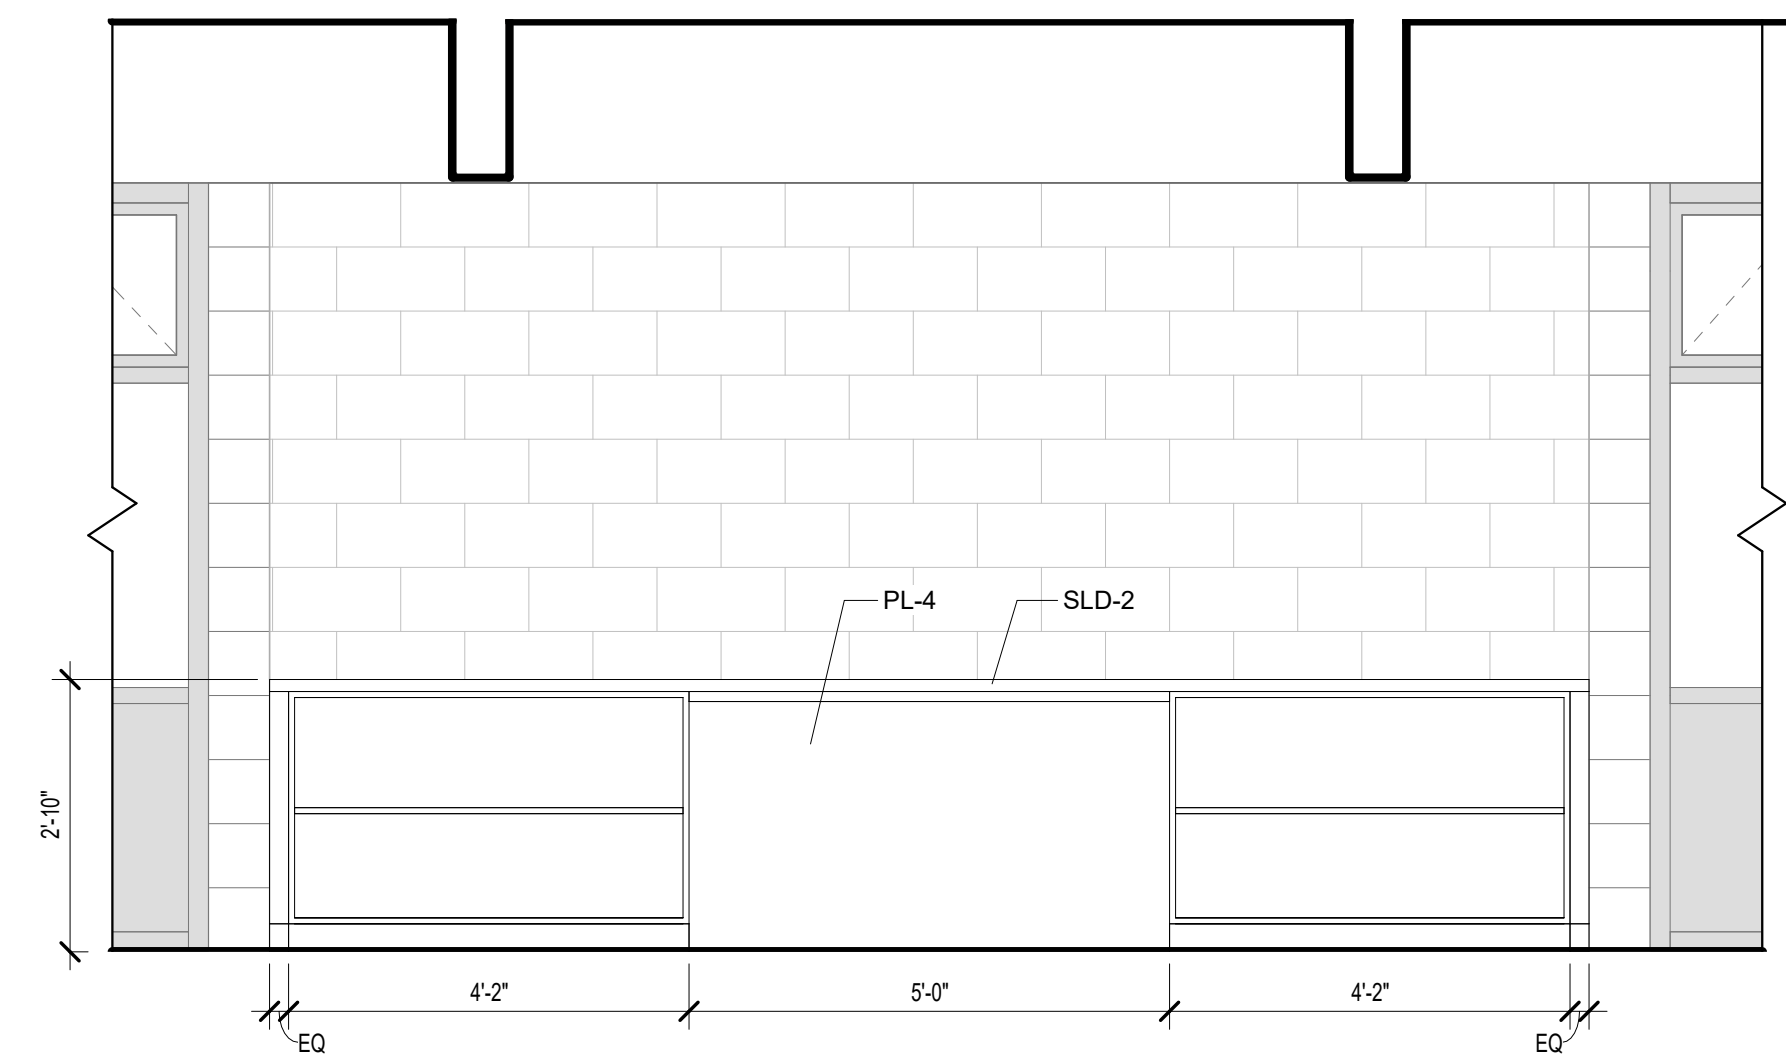


2 INTERIOR ELEVATION - CASEWORK - CLASSROOMS A102 & A107 - SOUTH
A404 1/2" = 1'-0"

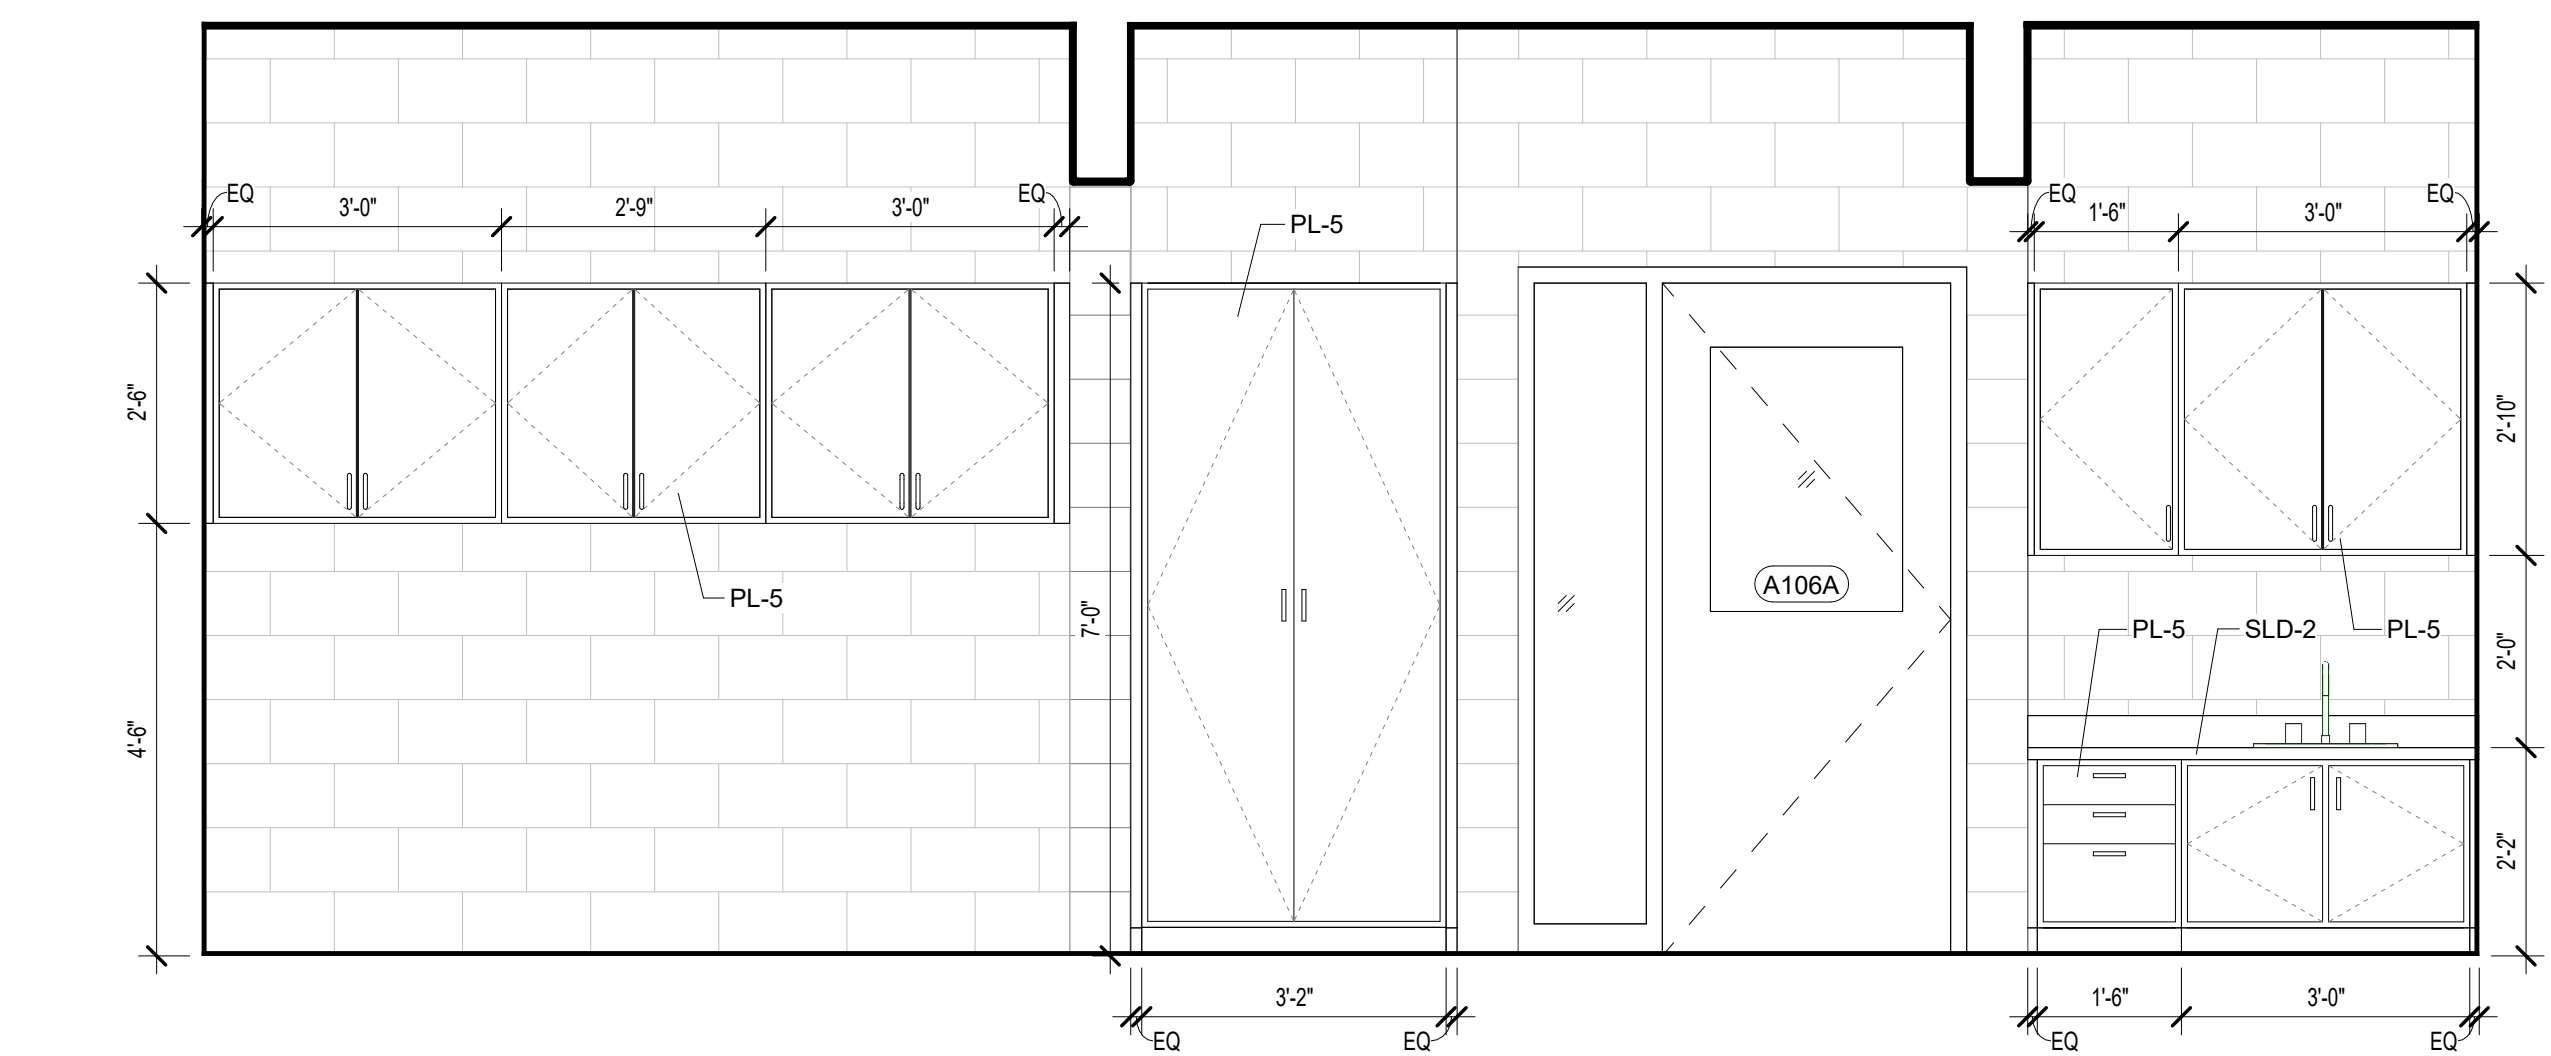


3 INTERIOR ELEVATION - CASEWORK - CLASSROOMS A103 & A106 - NORTH
A404 1/2" = 1'-0"

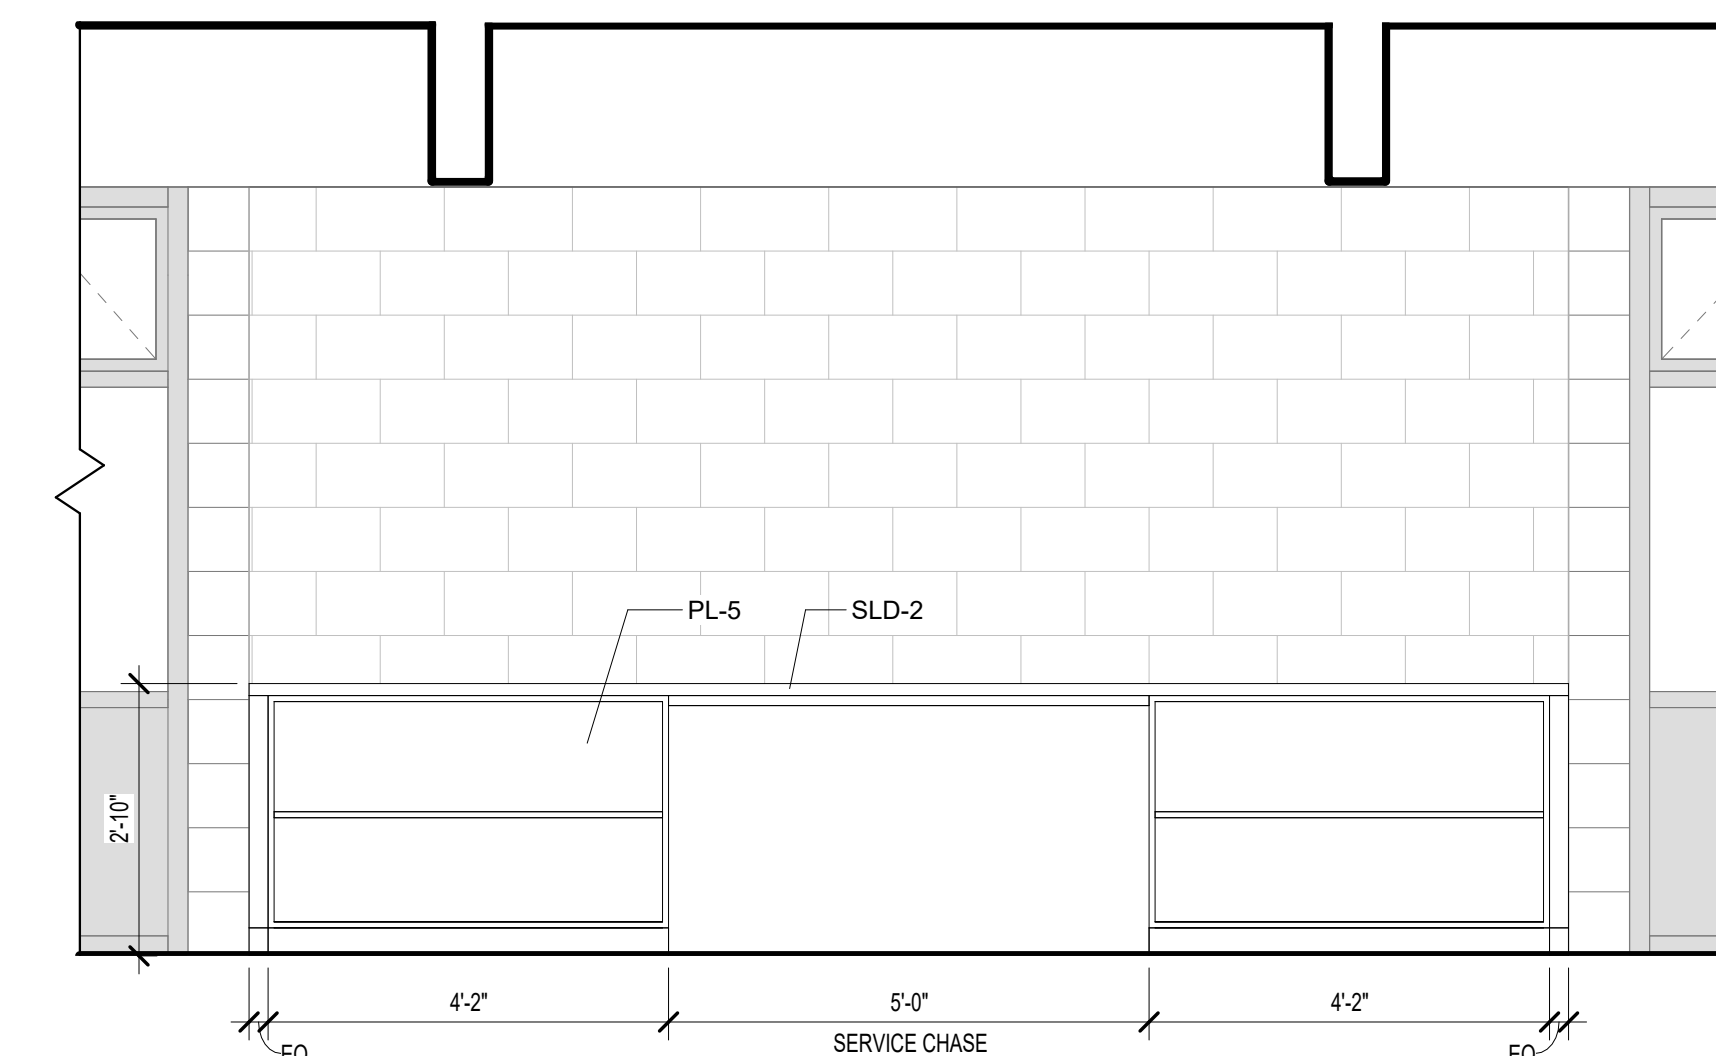

4 INTERIOR ELEVATION - CASEWORK - CLASSROOMS A103 & A106 - SOUTH
A404 1/2" = 1'-0"

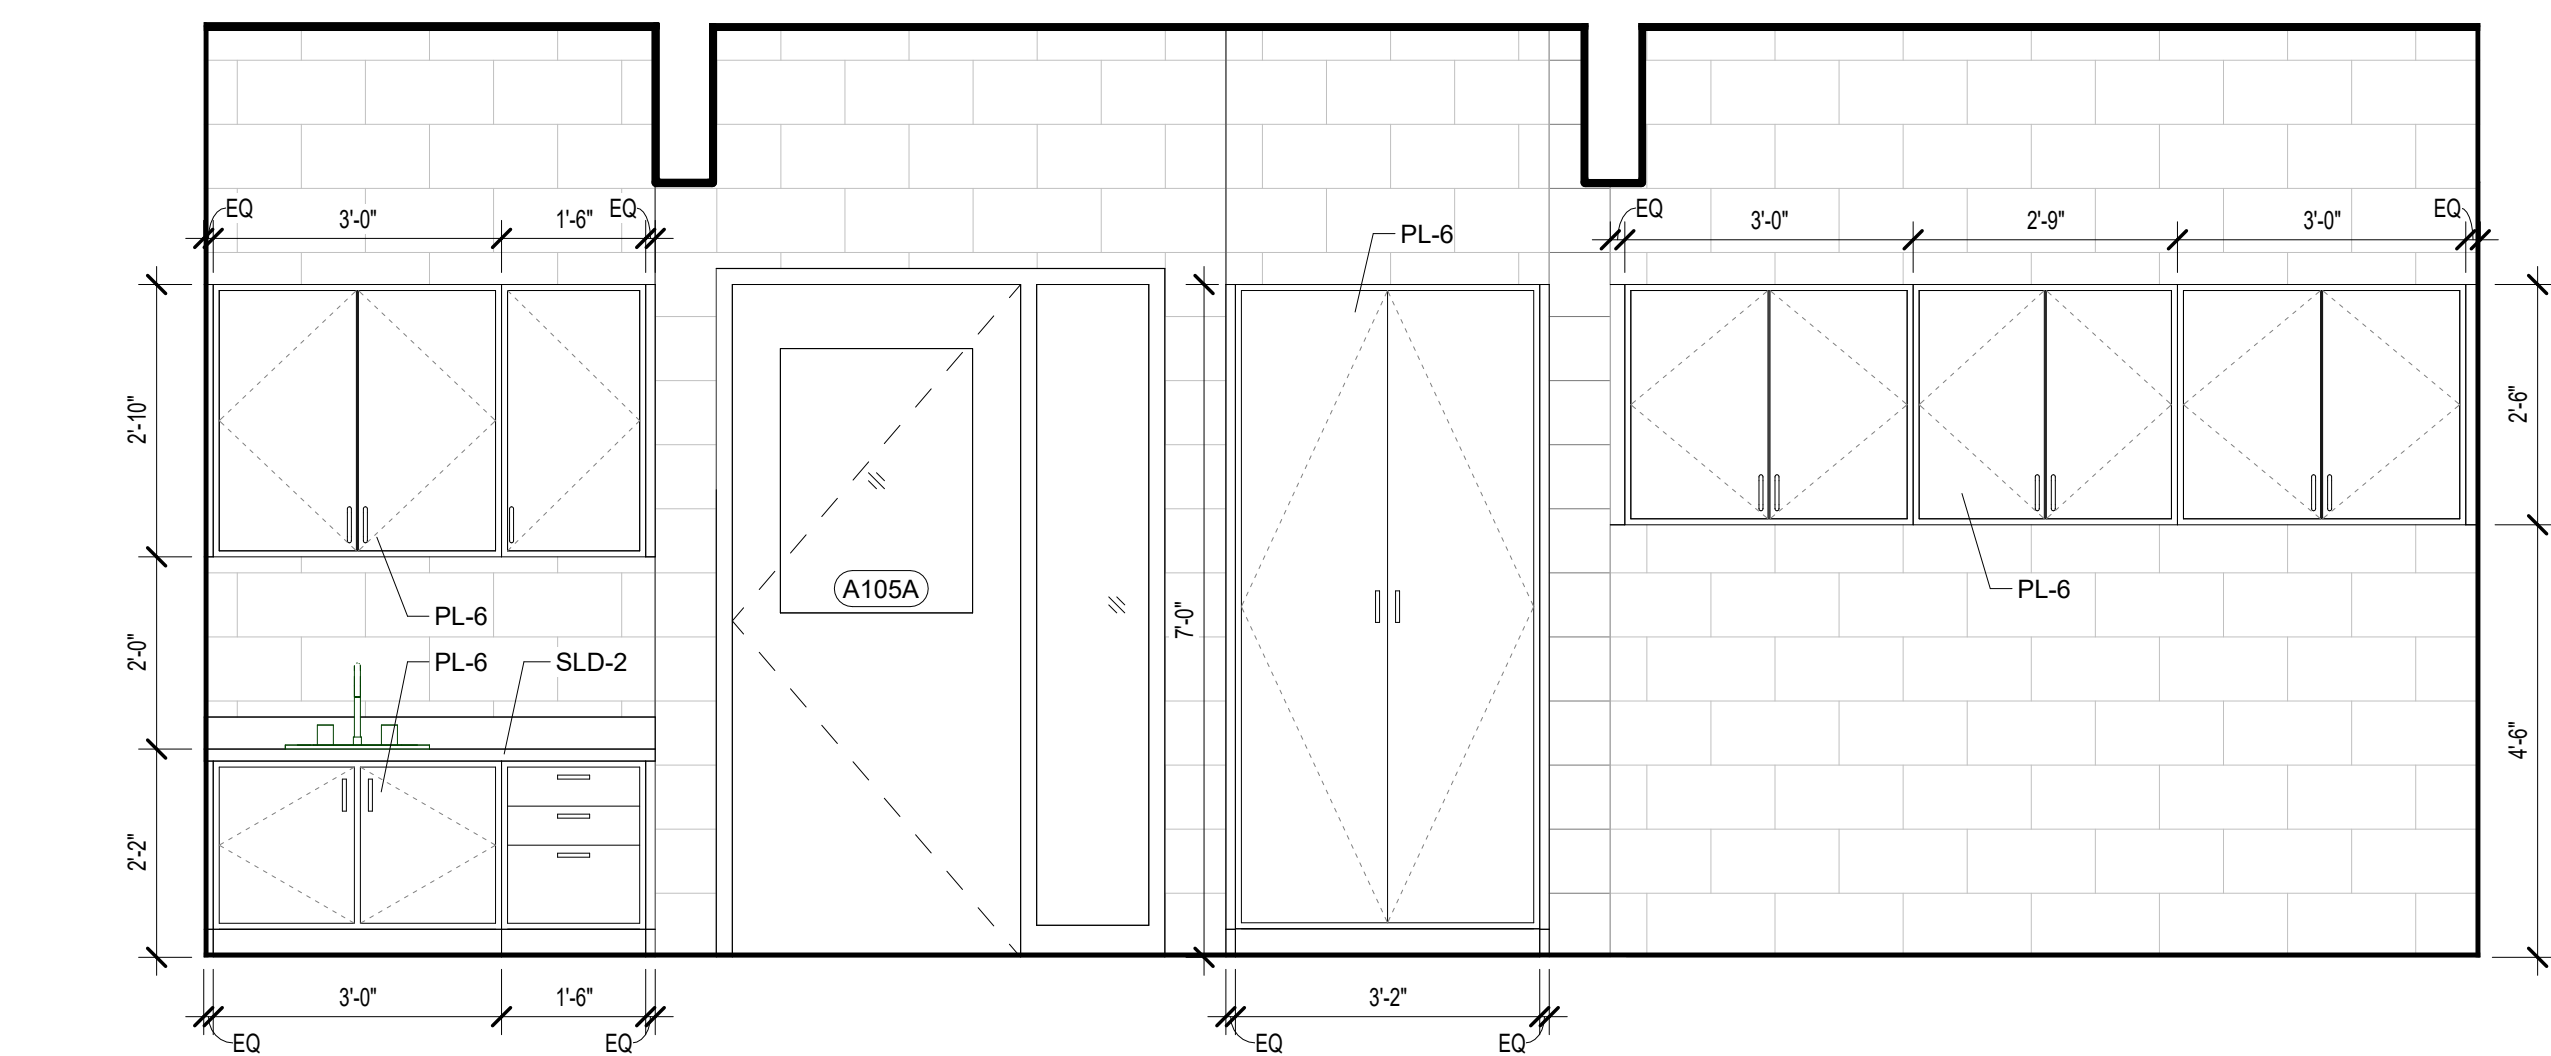

5 INTERIOR ELEVATION - CASEWORK - CLASSROOMS A104 & A105 - NORTH
A404 1/2" = 1'-0"

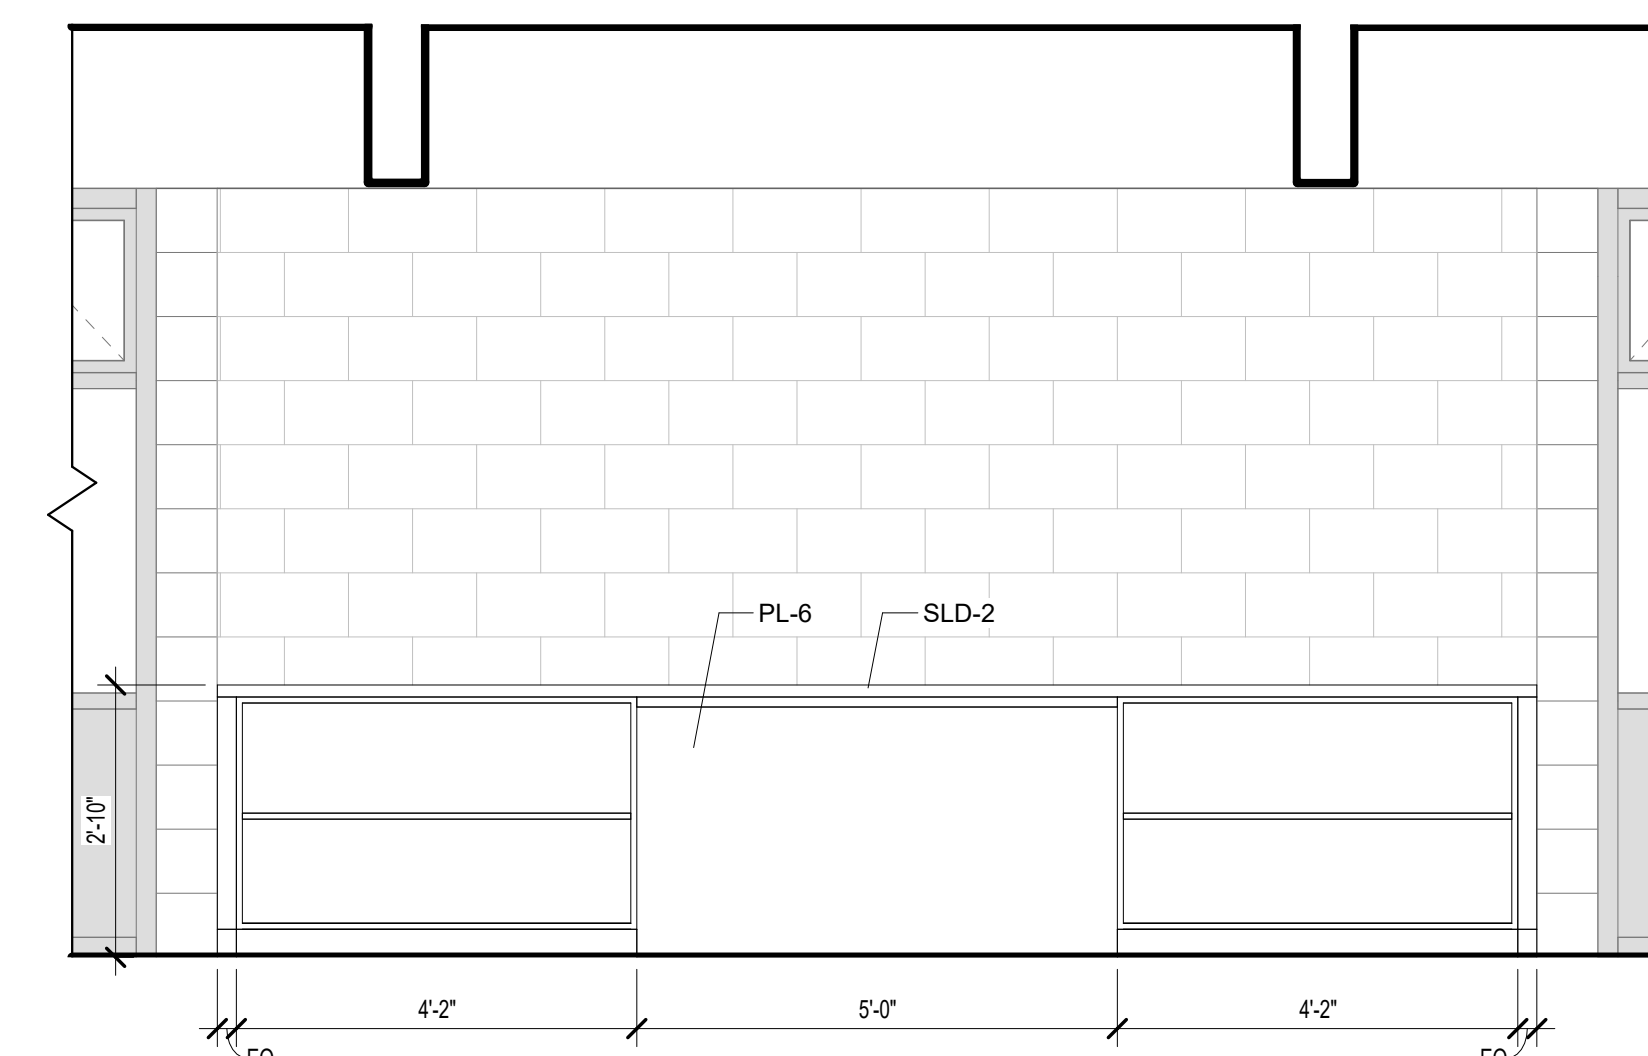

6 INTERIOR ELEVATION - CASEWORK - CLASSROOMS A104 & A105 - SOUTH
A404 1/2" = 1'-0"

INTERIOR ELEVATION NOTES

- A. SEE SPECIFICATIONS FOR FINISHES.
- B. PAINT INTERIOR LOUVERS, REGISTERS, DIFFUSERS, AND OTHER EXPOSED MATERIALS TO MATCH ADJACENT FINISHES.
- C. NOTIFY ARCHITECT, PRIOR TO INSTALLATION, IF DIMENSIONS SHOWN CREATE CONFLICT WITH CODES AND STANDARDS, MANUFACTURER RECOMMENDATIONS, OR FIELD CONDITIONS.



www.uptea.com

CENTRAL ELEMENTARY INTERIOR RENOVATION - PHASE 1

MENOMINEE COUNTY ISD
MENOMINEE, MI 49858

[illegible]

**CENTRAL ELEMENTARY INTERIOR
RENOVATION - PHASE 1
MENOMINEE COUNTY ISD**

PROJECT NO: M385-04227

DESIGNED BY:	JHR
DRAWN BY:	JHR
CHECKED:	WKM
APPROVED:	WKM

INTERIOR ELEVATIONS

A404

ROOM FINISH SCHEDULE										
ROOM NO.	ROOM NAME	FLOOR		WALLS				CEILING	REMARKS	
		MATERIAL	BASE	NORTH	SOUTH	EAST	WEST	MATERIAL		
A100	VEST	EXISTING	EXISTING	EXISTING	EXISTING	EXISTING	EXISTING	EXISTING		
A102	SPECIAL EED THERAPY	CPT-1	RB-1	PNT-1	PNT-1	PNT-1	PNT-1	EXISTING	1	
A103	STRONG BEGINNINGS	CPT-1	RB-1	PNT-1	PNT-1	PNT-2	PNT-1	EXISTING	1	
A104	GSRP	CPT-1	RB-1	PNT-1	PNT-1	PNT-1	PNT-1	EXISTING	1	
A105	CLASSROOM	EXISTING	EXISTING	EXISTING	EXISTING	EXISTING	EXISTING	EXISTING		
A106	CLASSROOM	EXISTING	EXISTING	EXISTING	EXISTING	EXISTING	EXISTING	EXISTING		
A106.1	TOILET	EXISTING	EXISTING	EXISTING	EXISTING	EXISTING	EXISTING	EXISTING		
A107	CLASSROOM	EXISTING	EXISTING	EXISTING	EXISTING	EXISTING	EXISTING	EXISTING		
A107.1	TOILET	EXISTING	EXISTING	EXISTING	EXISTING	EXISTING	EXISTING	EXISTING		
A109	CLASSROOM	EXISTING	RB-1	PNT-1	PNT-1	PNT-1	PNT-2	EXISTING	1	
A109.1	TOILET	CT-1	CT-2	PNT-2	PNT-2	PNT-2	PNT-2	EXISTING	1,2,3	
A109.2	STOR	CPT-1	RB-1	PNT-2	PNT-2	PNT-2	PNT-2	EXISTING	1	
A109.3	STOR	CPT-1	RB-1	PNT-2	PNT-2	PNT-2	PNT-2	EXISTING	1	
A110	CLASSROOM	EXISTING	RB-1	PNT-1	PNT-1	PNT-2	PNT-1	EXISTING	1	
A110.1	TOILET	CT-1	CT-2	PNT-2	PNT-2	PNT-2	PNT-2	EXISTING	1,2,3	
A110.2	STOR	CPT-1	RB-1	PNT-2	PNT-2	PNT-2	PNT-2	EXISTING	1	
A110.3	STOR	CPT-1	RB-1	PNT-2	PNT-2	PNT-2	PNT-2	EXISTING	1	
B110	OFFICE	CPT-1	RB-1	PNT-1	PNT-2	PNT-1	PNT-1	EXISTING	1	
B111	OFFICE	CPT-1	RB-1	PNT-2	PNT-1	PNT-1	PNT-1	EXISTING	1	

ROOM SCHEDULE REMARKS

1. PAINT COLORS TO BE PICKED DURING CONSTRUCTION
2. CERAMIC TILE CONTINUES UP WALL 4'-0".
3. CERAMIC TILE TO MATCH STYLE AND COLOR IN ROOM A106.

ROOM SCHEDULE ABBREVIATIONS

SEE A001 FOR STANDARD ARCHITECTURAL ABBREVIATIONS
SEE MATERIAL SCHEDULE FOR MATERIAL TYPES

CPT	CARPET
CT	CERAMIC TILE
PNT	PAINT
RB	RUBBER BASE



www.upea.com

CENTRAL ELEMENTARY INTERIOR RENOVATION - PHASE 1

MENOMINEE COUNTY ISD

MENOMINEE, MI 49858

MATERIAL SCHEDULE									
TYPE	DESCRIPTION	LOCATION	MANUFACTURER	BASIS OF DESIGN		REMARKS		TYPE	
				MODEL	COLOR	LOW EMITTING	MISCELLANEOUS		
ALUM-1	ALUMINUM FRAMED STOREFRONT DOOR	PER DOOR SCHEDULE	PER SPECS	AA 425 THERMAL ENTRANCES - ANODIZED ALUMINUM	#40 DARK BRONZE	LE-C		ALUM-1	
ALUM-2	ALUMINUM FRAMED STOREFRONT	PER WINDOW TYPE	PER SPECS	TRIFAB VERSA GLAZE 451T FRAMING SYSTEM	#40 DARK BRONZE	LE-C		ALUM-2	
CPT-1	CARPET TILE	PER ROOM SCHEDULE	MATCH CARPET IN A106	MATCH CARPET IN A106	MATCH CARPET IN A106	LE-C, LE-E		CPT-1	
CT-1	CERAMIC TILE - FLOOR	PER ROOM SCHEDULE	MATCH TOILET ROOM IN A106	MATCH TOILET ROOM IN A106	MATCH TOILET ROOM IN A106	LE-B		CT-1	
CT-2	CERAMIC TILE - WALL	PER ROOM SCHEDULE	MATCH TOILET ROOM IN A106	MATCH TOILET ROOM IN A106	MATCH TOILET ROOM IN A106	LE-B		CT-2	
PL-1	PLASTIC LAMINATE - CASEWORK	CASEWORK - OFFICES	PER SPECS	STANDARD LAMINATE	JUBILEE OAK 8242			PL-1	
PL-2	PLASTIC LAMINATE - CASEWORK	CASEWORK - CLASSROOM	PER SPECS	STANDARD LAMINATE	ORANGE CRUSH Y0733			PL-2	
PL-3	PLASTIC LAMINATE - CASEWORK	CASEWORK - CLASSROOM	PER SPECS	STANDARD LAMINATE	QUINCE 0346			PL-3	
PL-4	PLASTIC LAMINATE - CASEWORK	CASEWORK - CLASSROOM	PER SPECS	STANDARD LAMINATE	HOLLYBERRY D307			PL-4	
PL-5	PLASTIC LAMINATE - CASEWORK	CASEWORK - CLASSROOM	PER SPECS	STANDARD LAMINATE	CHUTNEY Y0852			PL-5	
PL-6	PLASTIC LAMINATE - CASEWORK	CASEWORK - CLASSROOM	PER SPECS	STANDARD LAMINATE	PEACOCK VELVET 15519			PL-6	
PNT-50	INTERIOR PAINT - WALL	PER ROOM SCHEDULE	PER SPECS	PROMAR 200 INTERIOR LATEX	MATCH FIELD PAINT IN A106	LE-F		PNT-50	
PNT-53	INTERIOR PAINT - WALL ACCENT	PER ROOM SCHEDULE	PER SPECS	PROMAR 200 INTERIOR LATEX	SUNNY VERANDA SW9017	LE-F		PNT-53	
PNT-54	INTERIOR PAINT - WALL ACCENT	PER ROOM SCHEDULE	PER SPECS	PROMAR 200 INTERIOR LATEX	RED BAY SW6321	LE-F		PNT-54	
PNT-70	INTERIOR PAINT - DOOR FRAME	PER DOOR SCHEDULE	PER SPECS	PROMAR 200 INTERIOR LATEX	SW7045 URBANE BRONZE	LE-F		PNT-70	
RB-1	RUBBER BASE	PER ROOM SCHEDULE	MATCH BASE IN A106	MATCH BASE IN A106	MATCH BASE IN A106	LE-D		RB-1	
SLD-1	SOLID SURFACE	COUNTERTOPS - OFFICES	LX HAUSYS	HI-MACS	POTENZA M604	LE-A, LE-C		SLD-1	
SLD-2	SOLID SURFACE	COUNTERTOPS - CLASSROOMS	LX HAUSYS	HI-MACS	RIPE COTTON G518R	LE-A, LE-C		SLD-2	
WD-3	FLUSH WOOD DOOR	PER DOOR SCHEDULE	EGGERS INDUSTRIES	EI-DOOR	WHITE MAPLE - TOFFEE TF24			WD-3	

MATERIAL SCHEDULE NOTES

- A. SEE INTERIOR ELEVATIONS AND ROOM SCHEDULE FOR LOCATION OF FINISHES.
- B. THE MATERIAL SCHEDULE PROVIDES A BASIS OF DESIGN

MATERIAL SCHEDULE REMARKS

MISCELLANEOUS
1. NOT USED

LOW EMITTING

LE-A	COMPOSITE WOOD AND AGRIFFER PRODUCTS (INCLUDING ASSOCIATED SUBSTRATE) MUST CONTAIN NO ADDED UREA-FORMALDEHYDE.
LE-B	CLEAR WOOD FINISHES, FLOOR COATINGS, STAINS, PRIMER SEALERS AND SHELLS (INCLUDING TILE SETTING ADHESIVE, AND GROUT) APPLIED TO INTERIOR ELEMENTS MUST NOT EXCEED THE VOC CONTENT LIMITS ESTABLISHED IN SCAQMD RULE 1113 AS OF 01 JAN 2004.
LE-C	ADHESIVES, SEALANTS, AND SEALANT PRIMERS APPLIED TO FLOOR OR WALL SURFACES MUST COMPLY WITH SCAQMD RULE 1168 AS OF 01 JULY 2005. AEROSOL ADHESIVES APPLIED TO INTERIOR ELEMENTS MUST COMPLY WITH GREEN SEAL GS-36 AS OF 19 OCTOBER 2000.
LE-D	HARD SURFACE FLOORING AND WALL BASE MUST BE FIBRORE CEMENT.
LE-E	CARPET MUST MEET GREEN LABEL PLUS REQUIREMENTS. CARPET CUSHION MUST MEET GREEN LABEL REQUIREMENTS.
LE-F	ARCHITECTURAL PAINTS AND COATINGS APPLIED TO INTERIOR ELEMENTS MUST NOT EXCEED THE VOC CONTENT LIMITS ESTABLISHED IN GREEN SEAL STANDARD GS-11 AS OF 20 MAY 1993.

MATERIAL SCHEDULE ABBREVIATIONS

SEE A001 FOR STANDARD ARCHITECTURAL ABBREVIATIONS
MATERIAL TYPES DEFINED IN MATERIAL SCHEDULE


MFSD SPEC TYP	MANUFACTURER'S STANDARD SPECIFICATION TYPICAL
---------------------	---

CENTRAL ELEMENTARY INTERIOR RENOVATION - PHASE 1 MEMORIEE COUNTY ISD PROJECT NO. M385-04227		ISSUED FOR: OWNER REVIEW OWNER REVIEW OWNER REVIEW PLAN REVIEW BIDDING	DATE: 02-20-2025 04-04-2025 04-11-2025 04-25-2025
DESIGNED BY: JHR			
DRAWN BY: JHR			
CHECKED: WKM			
APPROVED: WKM			

ARCHITECTURAL SCHEDULES AND TYPES - ROOM

A601

DOOR SCHEDULE											
DOOR NUMBER	DIMENSIONS		DOOR		FRAME		POWER / SECURITY	HARDWARE GROUP	REMARKS		DOOR NUMBER
	WIDTH	HEIGHT	CONSTRUCTION	TYPE	CONSTRUCTION	TYPE					
A102.1A	2'-8"	7'-0"	WD	F	HM	S		2			A102.1A
A102A	3'-0"	7'-0"	WD		HM	SL		1			A102A
A102B	3'-0"	7'-0"	ALUM	FG2	ALUM	STF1	YES	3			A102B
A103.1A	2'-8"	7'-0"	WD	F	HM	S		2			A103.1A
A103A	3'-0"	7'-0"	WD	G	HM	SL		1			A103A
A103B	3'-0"	7'-0"	ALUM	FG2	ALUM	STF1	YES	3			A103B
A104.1A	2'-8"	7'-0"	WD	F	HM	S		2			A104.1A
A104A	3'-0"	7'-0"	WD	G	HM	SL		1			A104A
A104B	3'-0"	7'-0"	ALUM	FG2	ALUM	STF1	YES	3			A104B
A105.1A	2'-8"	7'-0"	WD	F	HM	S		2			A105.1A
A105A	3'-0"	7'-0"	WD	G	HM	SL		1			A105A
A105B	3'-0"	7'-0"	ALUM	FG2	ALUM	STF1	YES	3			A105B
A106.1A	2'-8"	7'-0"	WD	F	HM	S		2			A106.1A
A106A	3'-0"	7'-0"	WD	G	HM	SL		1			A106A
A106B	3'-0"	7'-0"	ALUM	FG2	ALUM	STF1	YES	3			A106B
A107.1A	2'-8"	7'-0"	WD	F	HM	S		2			A107.1A
A107A	3'-0"	7'-0"	WD	G	HM	SL		1			A107A
A107B	3'-0"	7'-0"	ALUM	FG2	ALUM	STF1	YES	3			A107B
A109.1A	2'-4"	7'-0"	WD	F	HM	S		2			A109.1A
A109.2A	2'-4"	7'-0"	WD	F	HM	S		5			A109.2A
A109.3A	2'-4"	7'-0"	WD	F	HM	S		5			A109.3A
A109A	3'-0"	7'-0"	WD	G	HM	S		1			A109A
A109B	3'-0"	7'-0"	ALUM	FG2	ALUM	STF3	YES	3			A109B
A110.1A	2'-4"	7'-0"	WD	F	HM	S		2			A110.1A
A110.2A	2'-4"	7'-0"	WD	F	HM	S		5			A110.2A
A110.3A	2'-4"	7'-0"	WD	F	HM	S		5			A110.3A
A110A	3'-0"	7'-0"	WD	G	HM	S		1			A110A
A110B	3'-0"	7'-0"	ALUM	FG2	ALUM	STF3	YES	3			A110B
B110A	3'-0"	7'-0"	WD	F	HM	SL		4			B110A
B111A	3'-0"	7'-0"	WD	F	HM	SL		4			B111A
B111B	3'-0"	7'-0"	WD	F	HM	S		4			B111B

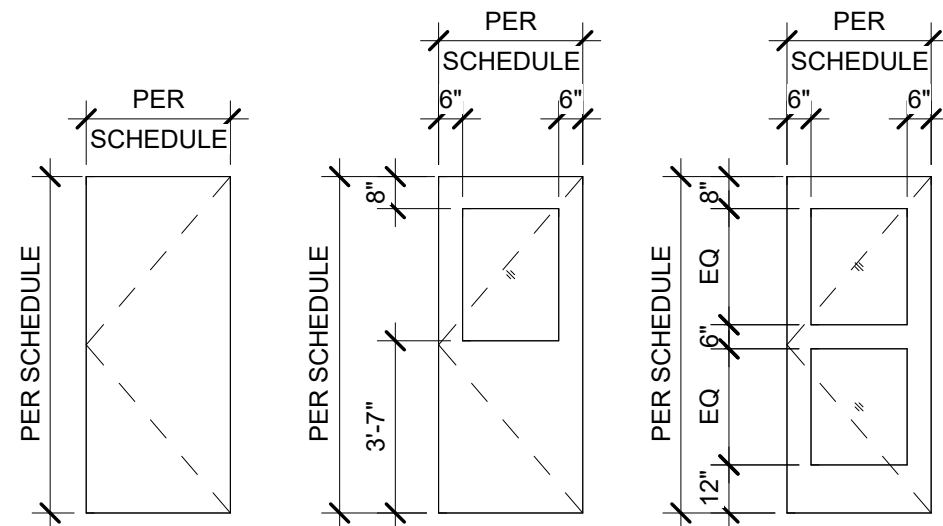


F
FLUSH

G
GLASS

FG2
FULL GLASS
TWO LITE

DOOR TYPES

FRAME TYPES

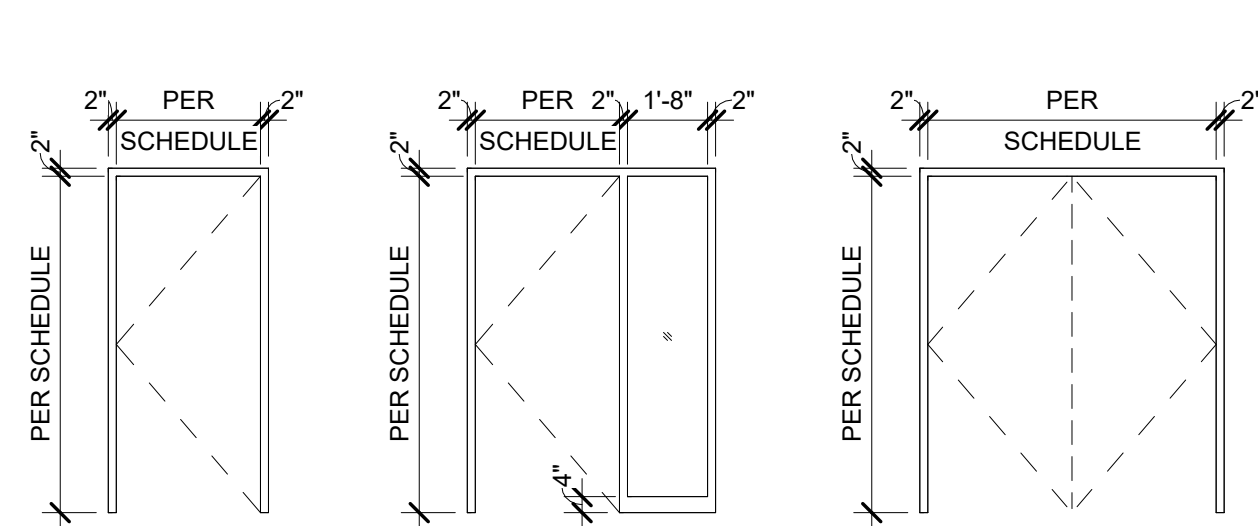


S
SINGLE


SL
SINGLE
LATCHLITE

P
PAIR


PHHT
PAIR
HINGELIGHT
TRANSMOM

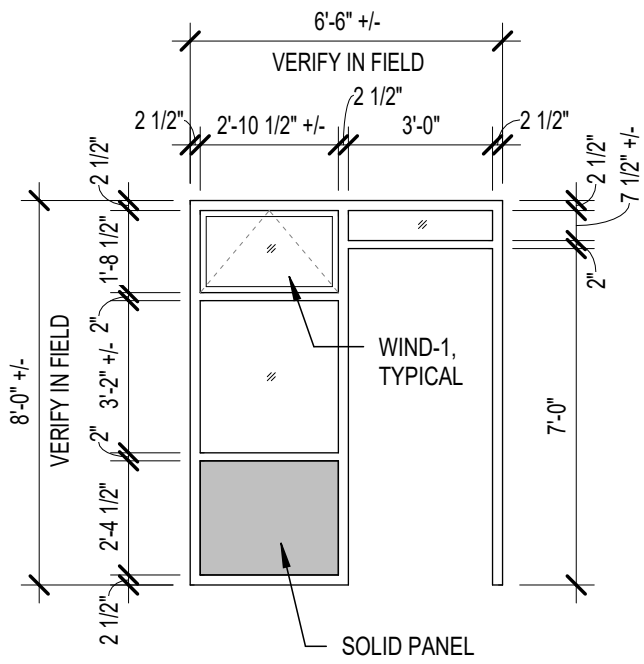

STF1
STOREFRONT 1

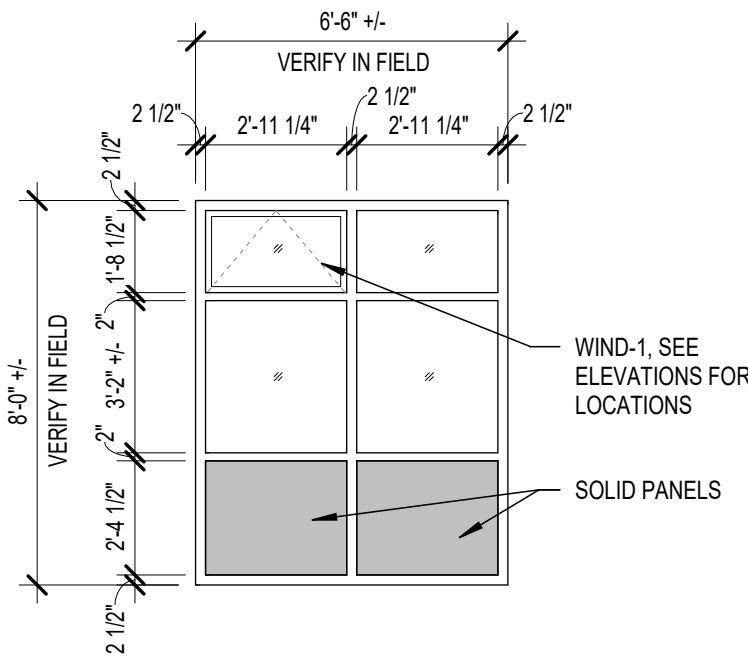


STF2
STOREFRONT 2

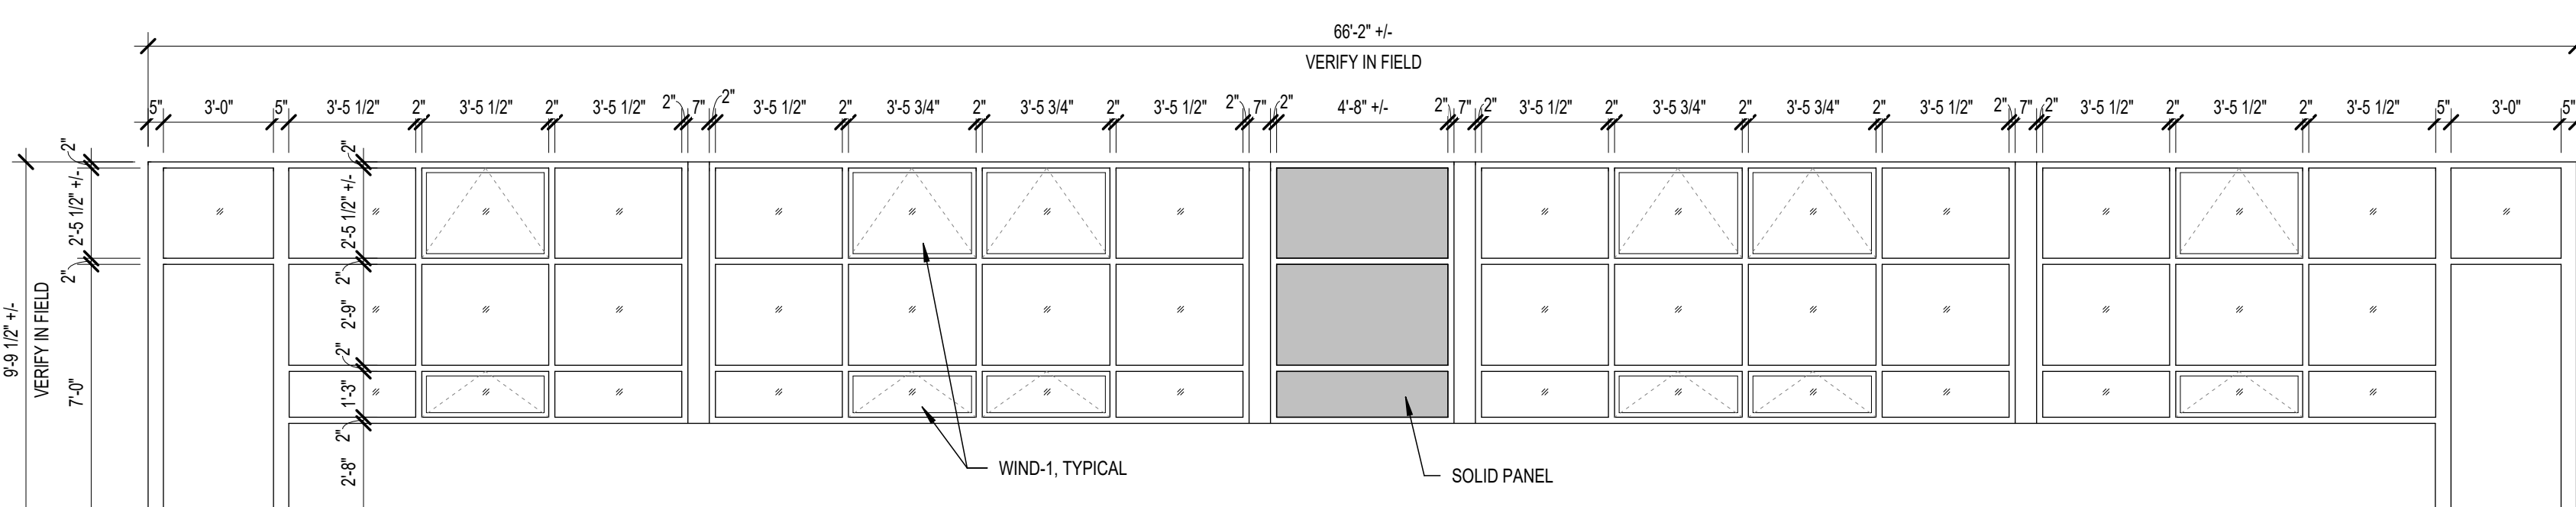

STF3
STOREFRONT 3

STOREFRONT TYPES

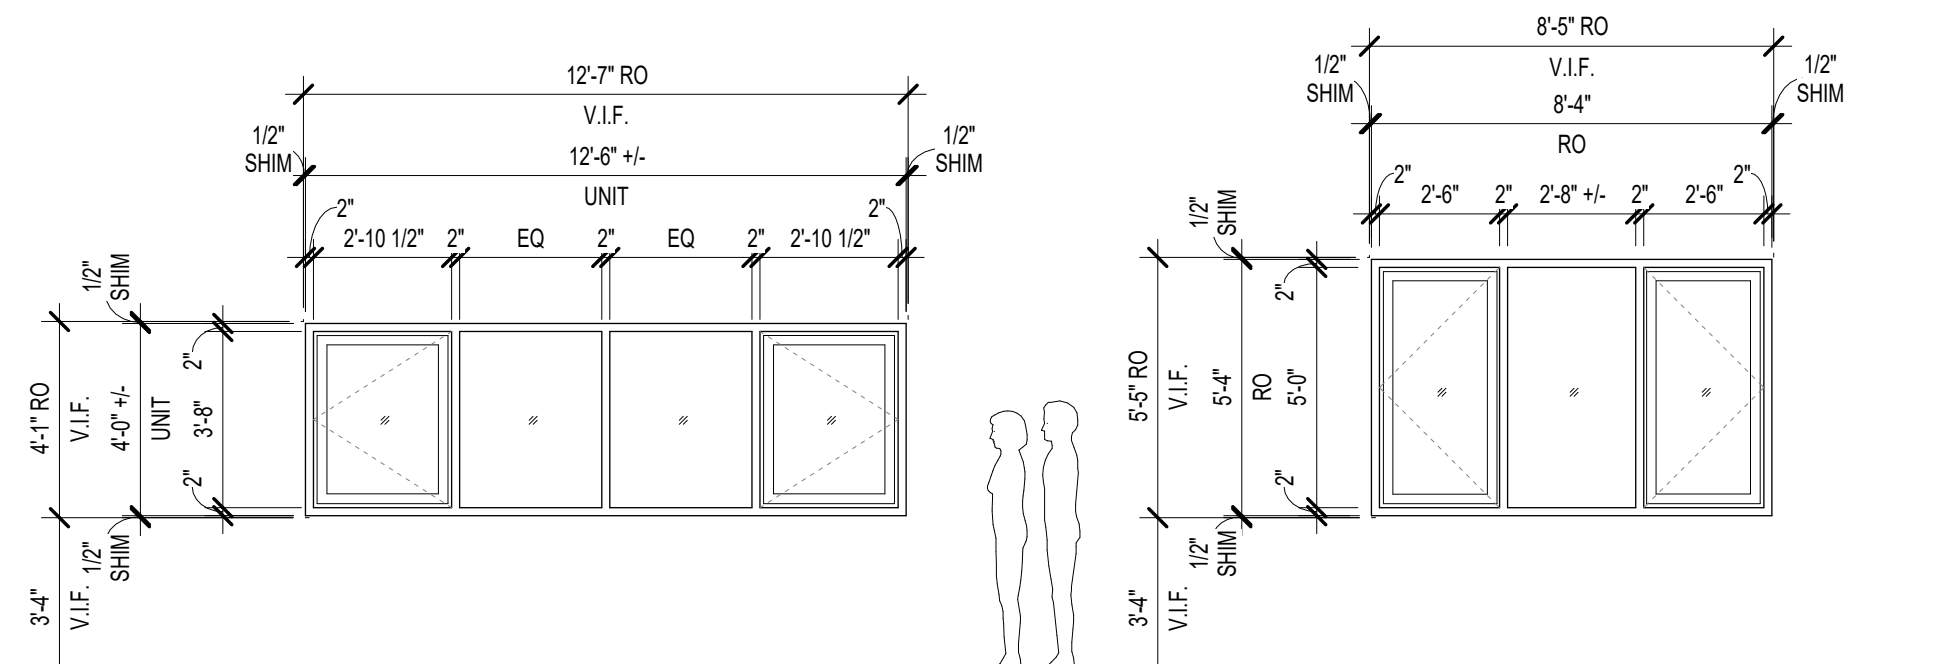

STF4

STF5

WINDOW TYPES

DOOR SCHEDULE AND TYPE NOTES

- SAFETY GLAZING SHALL BE PROVIDED WHERE REQUIRED BY IBC.
- FIELD VERIFY EXISTING DOOR OPENING DIMENSIONS. COORDINATE ROUGH OPENING AND SHIM SPACE WITH MANUFACTURER.
- PROVIDE 1/2" SHIM SPACE ALL SIDES OF EXTERIOR DOORS TO MAINTAIN ADEQUATE SPACE FOR FULL DEPTH SPRAY FOAM INSULATION. CONTRACTOR IS RESPONSIBLE FOR COORDINATION AND ACCURACY OF SHOP DRAWINGS.
- DOOR AND FRAME TYPES REPRESENTED AS VIEWED FROM EXTERIOR SIDE UNLESS NOTED OTHERWISE.
- FOR DOORS AND FRAMES INSTALLED WITH INTERIOR ON BOTH SIDES; SEE PLANS AND ELEVATIONS FOR ORIENTATION.
- COORDINATE POWER AND SECURITY WITH OWNER REQUIREMENTS AND EXISTING SYSTEM.

DOOR SCHEDULE ABBREVIATIONS

SEE A001 FOR STANDARD ARCHITECTURAL ABBREVIATIONS
SEE MATERIAL SCHEDULE FOR MATERIAL TYPES

ALUM	ALUMINUM STOREFRONT
HM	HOLLOW METAL
INHM	INSULATED HOLLOW METAL
MFS	MANUFACTURER STANDARD FINISH
TBHM	THERMALLY BROKEN HOLLOW METAL
WD	WOOD

DOOR HARDWARE GROUPS

HARDWARE GROUP 1

- 3 EA HINGES
- 1 EA CLASSROOM LOCKSET-MORTISE
- 1 EA ELECTRIC STRIKE AND SECURITY PER OWNER REQUIREMENTS
- 1 EA CLOSER w/ INTEGRATED STOP

HARDWARE GROUP 2

- 3 EA HINGES
- 1 EA PRIVACY LOCKSET-BORED (CYLINDRICAL)
- 1 EA CLOSER w/ INTEGRATED STOP

HARDWARE GROUP 3

- 3 EA HINGES
- 1 EA RIM EXIT DEVICE EXIT ONLY (NO EXTERIOR TRIM)-MORTISE
- 1 EA CLOSER w/ INTEGRATED STOP
- 1 EA THRESHOLD
- WEATHERSTRIPPING

HARDWARE GROUP 4

- 3 EA HINGES
- 1 EA OFFICE LOCKSET-MORTISE
- 1 EA CLOSER w/ INTEGRATED STOP

HARDWARE GROUP 5

- 3 EA HINGES
- 1 EA STORAGE LOCKSET-BORED (CYLINDRICAL)
- 1 EA OVERHEAD STOP

WINDOW TYPE NOTES

- FOR THE PURPOSE OF THESE NOTES THE TERM 'WINDOW' INCLUDES, BUT IS NOT LIMITED TO; STOREFRONT, CURTAINWALL, RELITE, SIDELITE, TRANSMOM, AND TRANSLUCENT PANELS.
- SAFETY GLAZING SHALL BE PROVIDED WHERE REQUIRED BY IBC.
- WINDOW TYPES REPRESENTED AS VIEWED FROM EXTERIOR SIDE UNLESS NOTED OTHERWISE.
- FIELD VERIFY EXISTING WINDOW OPENING DIMENSIONS. COORDINATE ROUGH OPENING AND SHIM SPACE WITH MANUFACTURER.
- PROVIDE 1/2" SHIM SPACE ALL SIDES OF EXTERIOR WINDOWS TO MAINTAIN ADEQUATE SPACE FOR FULL DEPTH SPRAY FOAM INSULATION. CONTRACTOR IS RESPONSIBLE FOR COORDINATION AND ACCURACY OF SHOP DRAWINGS.

CENTRAL ELEMENTARY INTERIOR
RENOVATION - PHASE 1

MENOMINEE COUNTY ISD

MENOMINEE, MI 49858

ISSUED FOR:	DATE:
OWNER REVIEW	02-20-2025
OWNER REVIEW	04-04-2025
PLAN REVIEW	04-11-2025
BIDDING	04-25-2025

CENTRAL ELEMENTARY INTERIOR
RENOVATION - PHASE 1
MENOMINEE COUNTY ISD
PROJECT NO: M385-04227

DESIGNED BY: JHR
DRAWN BY: JHR
CHECKED: WKM
APPROVED: WKM

ARCHITECTURAL
SCHEDULES AND
TYPES - DOOR

A602